



The present document or drawing is property of TECHNIP ITALY S.p.A. and shall not, under any circumstances, be totally or partially directly or indirectly, transferred, reproduced, copied, disclosed or used, without its prior written consent, for any purpose and in any way other than that for which it is specifically furnished or authorized.

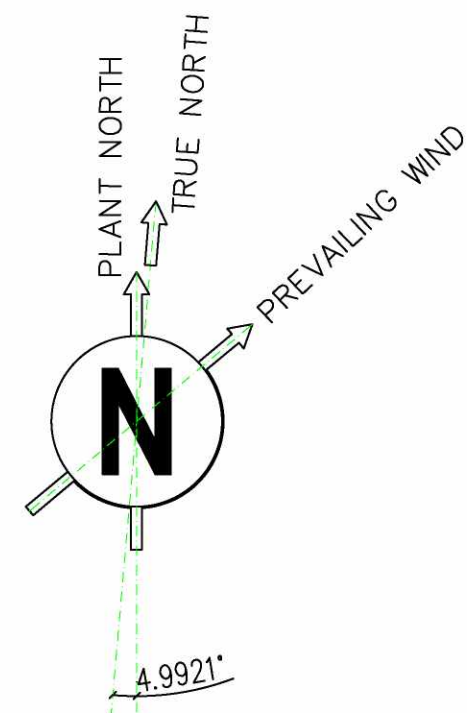


FOR CONTINUATION SEE DWG 082755C-000-DW-1442-0001-02
PART 1

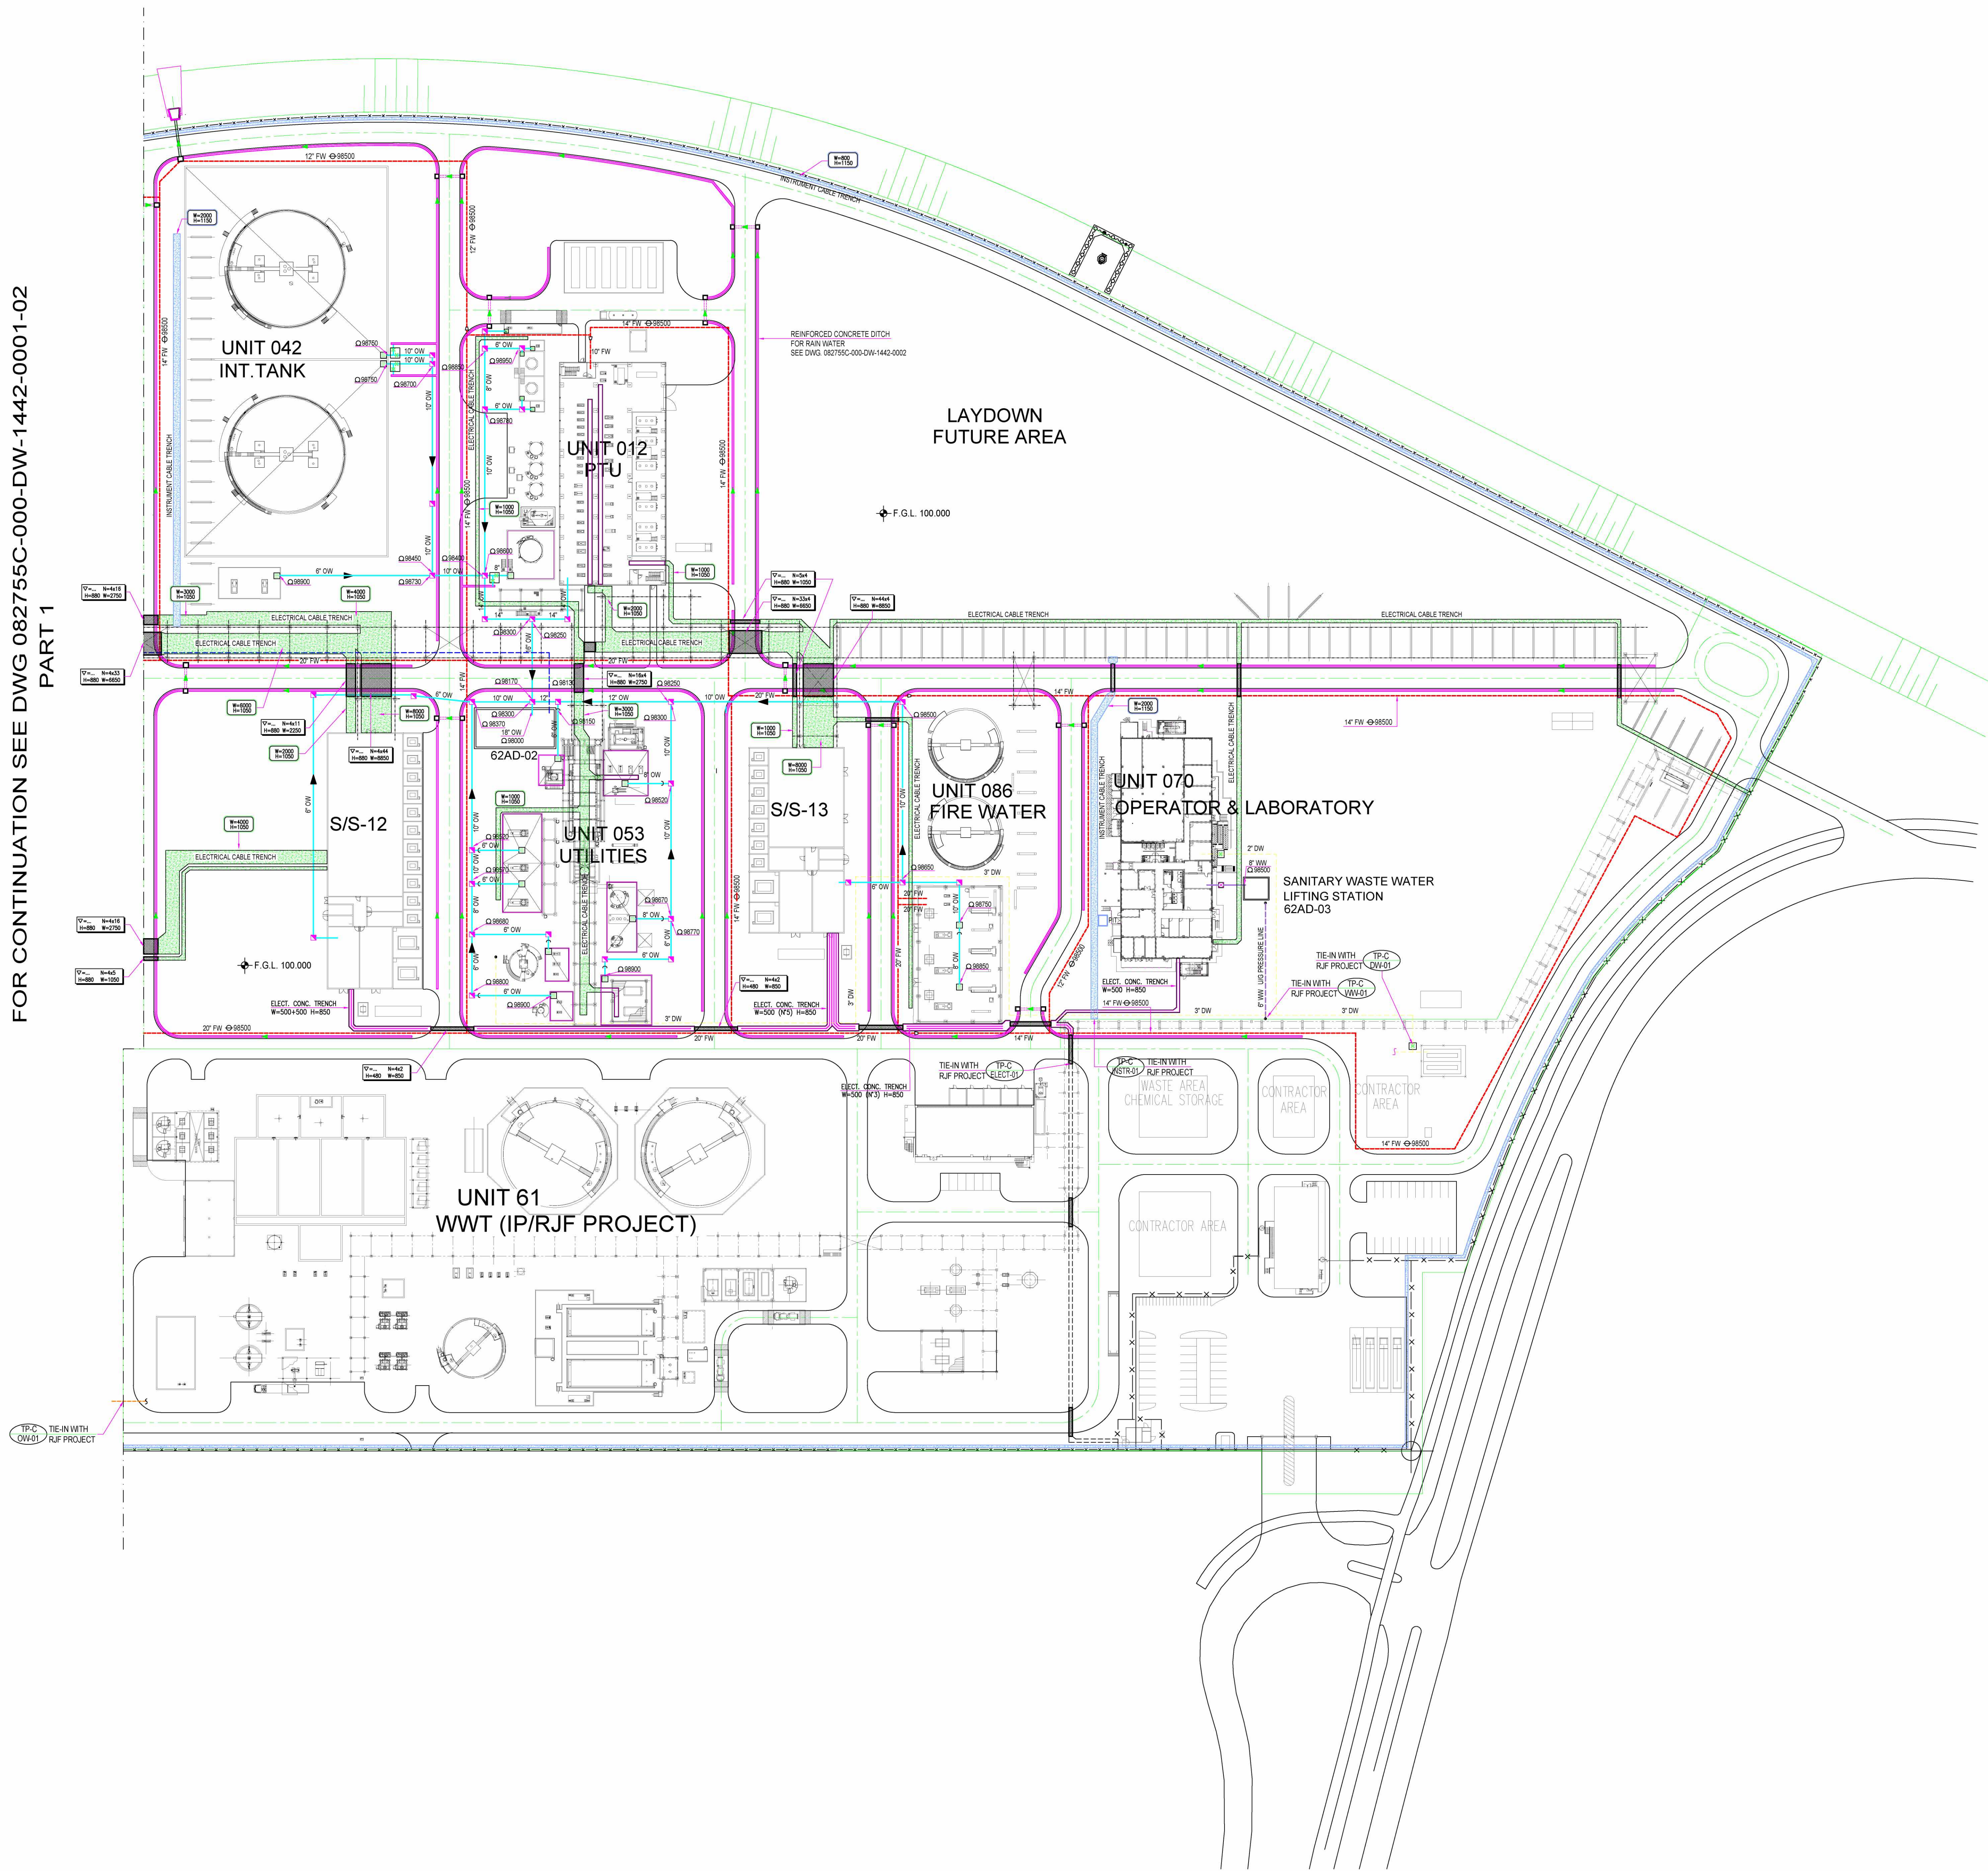

GENERAL NOTES

LEGEND

- MANHOLE FOR OILY WATER SEWER
- CATCH BASIN FOR OILY WATER SEWER
- VALVE PIT
- RAIN WATER
- OILY WASTE WATER GRAVITY LINE
- OILY WASTE WATER PRESSURE LINE (UNDERGROUND)
- OILY WASTE WATER PRESSURE LINE (ABOVE GROUND)
- FIRE WATER
- DRINKING WATER
- SANITARY WASTE WATER (GRAVITY LINE)
- SANITARY WASTE WATER (PRESSURE LINE)

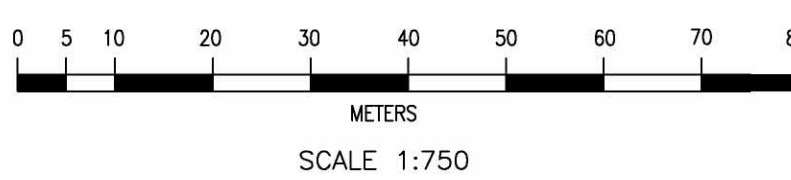

082755C-000	REFINERY AREA PLOT PLAN - RDCG PROJECT
DW-0001-0000	CIVIL AND STRUCTURAL UNDERGROUND SYSTEMS
082755C-000	SITE FINISHING AND MISCELLANEOUS - DESIGN STANDARD
082755C-000	GENERAL NOTES FOR UNDERGROUND WORKS
DW-1402-001	DESCRIPTION

REFERENCE DRAWINGS

CONFIDENTIAL

A	2011	ISSUED FOR REVIEW	PREP	CKD	APPR/AUTH
REV	DATE	DESCRIPTION	PREP	CKD	APPR/AUTH

NESTE TechnipFMC

RDCG (Rotterdam Capacity Growth) - FEASIBILITY PHASE
NESTE

MAJOR UNDERGROUND & PIPING LAYOUT
MNA AREA - PART 2

Scale	Technip Drawing No	Page	Rev.
1/750	082755C 000 DW 14 42 0001 Project Unit Doc.Type Disc Subj Ser.No	3of4	A

NESTE Drawing No