

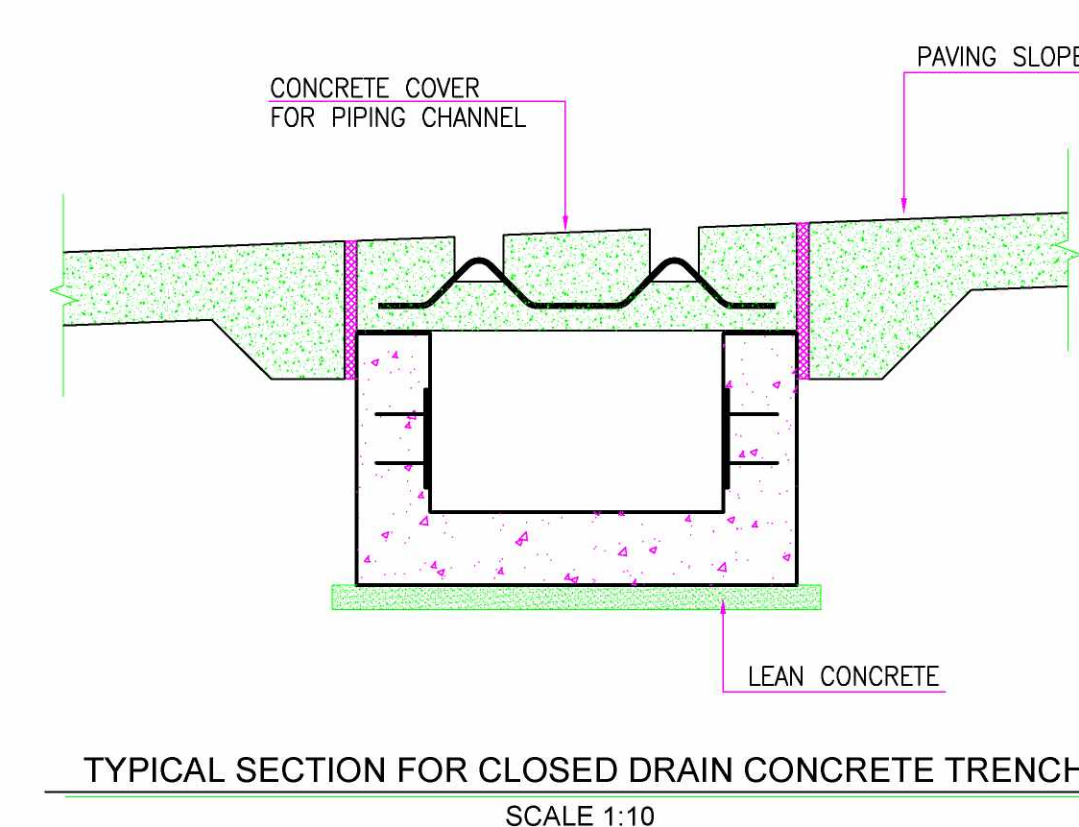
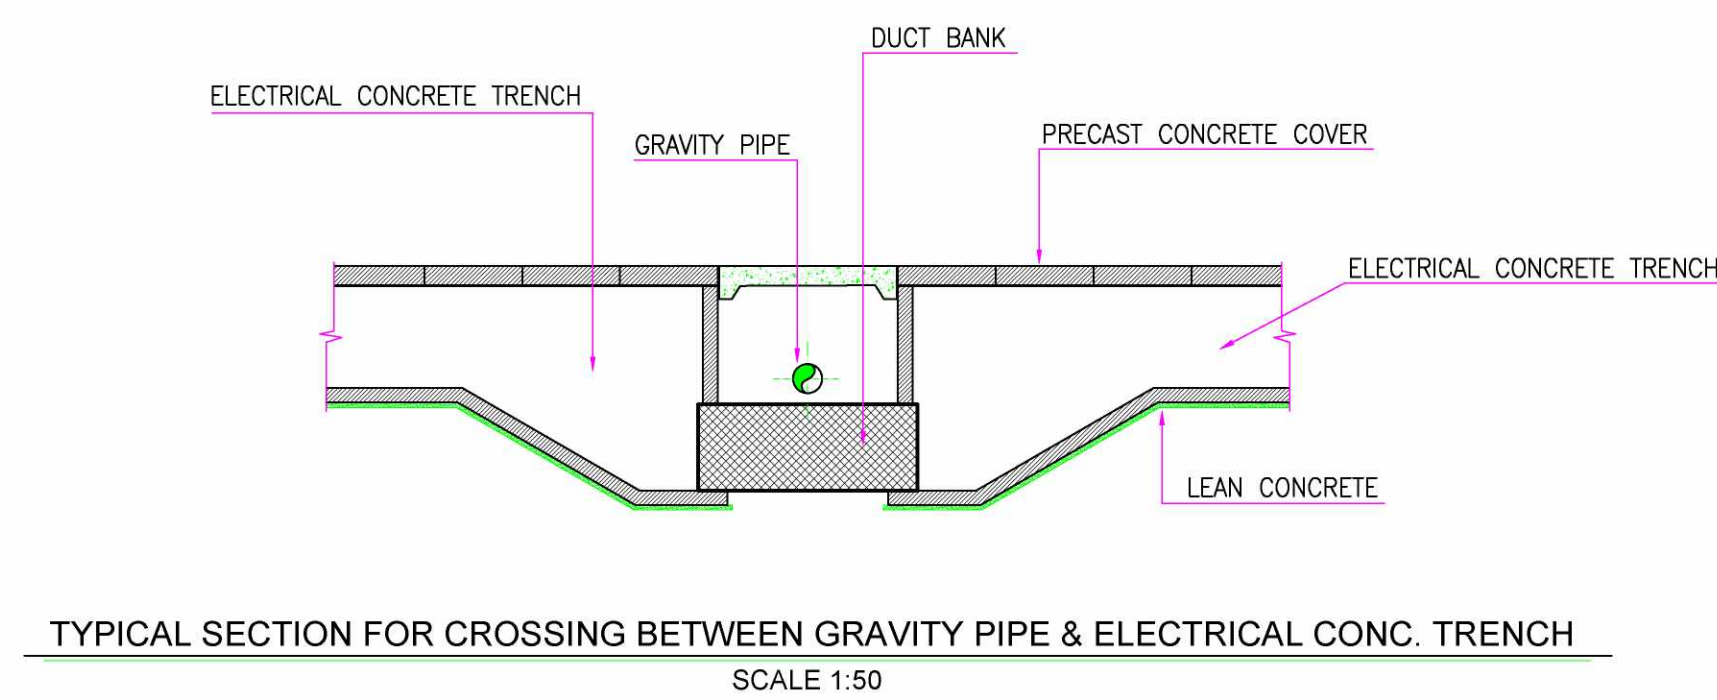


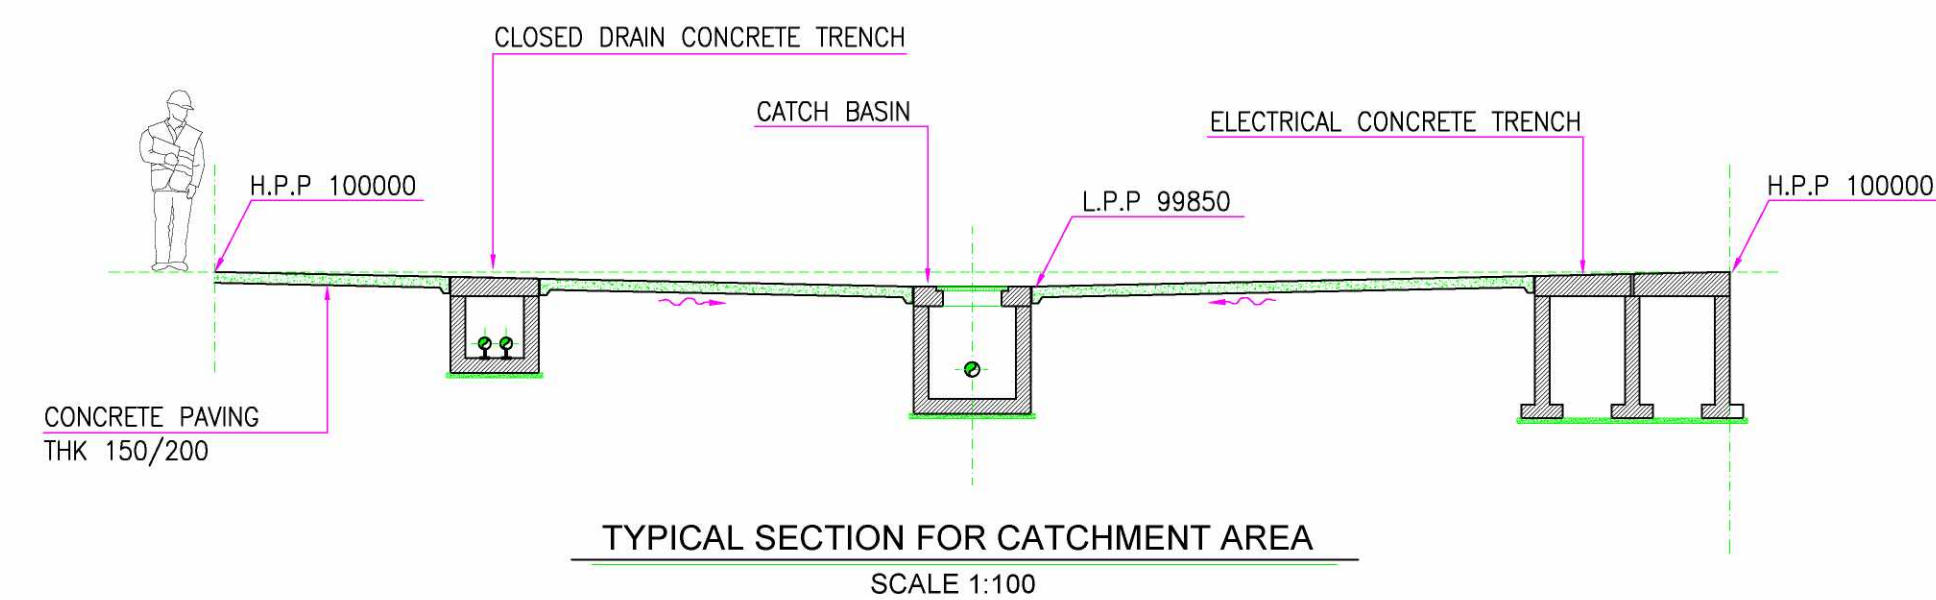

FOR CONTINUATION SEE DWG 082755C-000-DW-1442-0001-03
PART 2

LEGEND

- MANHOLE FOR OILY WATER SEWER
- CATCH BASIN FOR OILY WATER SEWER
- VALVE PIT
- RAIN WATER
- OILY WASTE WATER GRAVITY LINE
- OILY WASTE WATER PRESSURE LINE (UNDERGROUND)
- OILY WASTE WATER PRESSURE LINE (ABOVE GROUND)
- FIRE WATER
- CLOSED DRAIN CONCRETE TRENCH

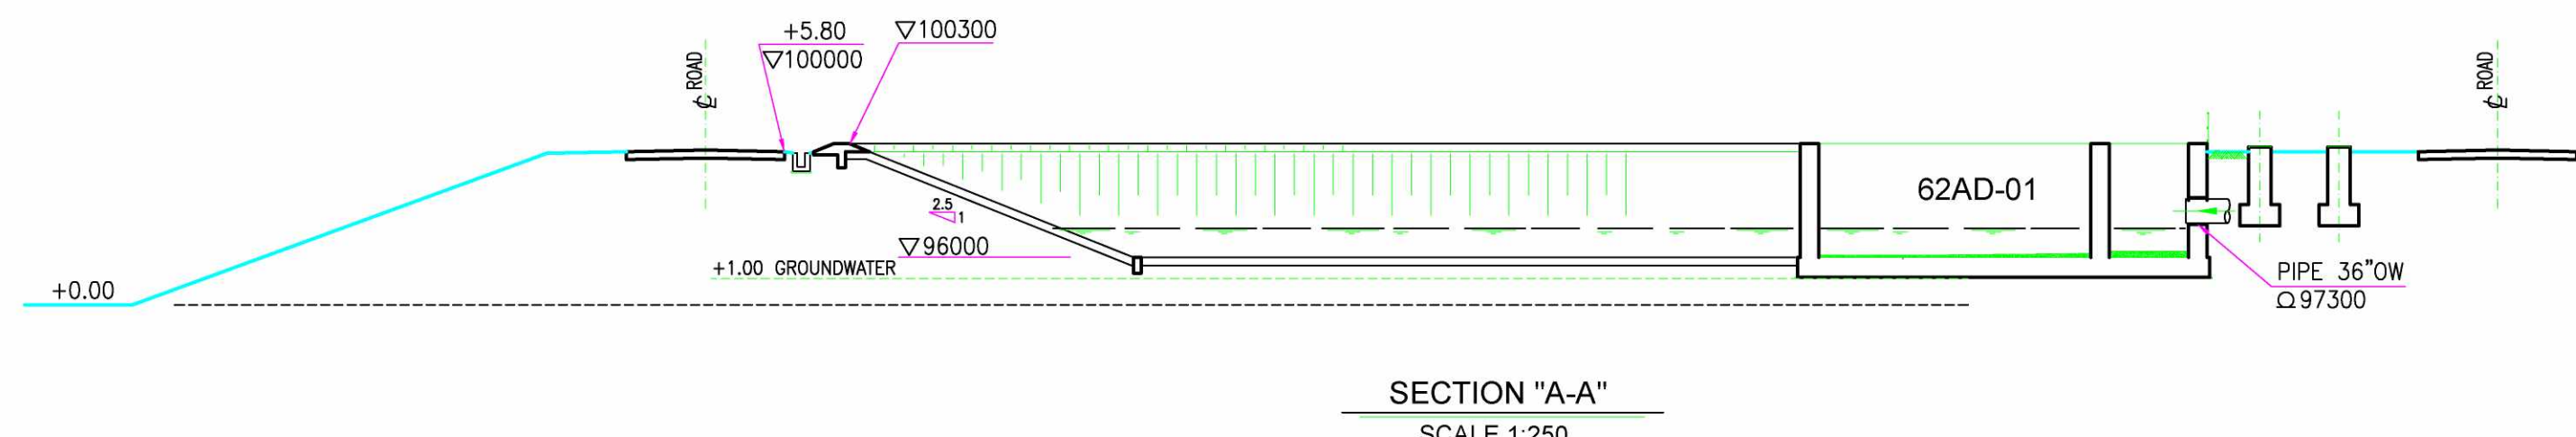

082755C-000 DW-0051-0005	REFINERY AREA PLOT PLAN - RDCG PROJECT
082755C-000 STD-1480-0001	CIVIL AND STRUCTURAL UNDERGROUND SYSTEMS, SITE FINISHING AND MISCELLANEOUS - DESIGN STANDARD
082755C-000 DW-1402-001	GENERAL NOTES FOR UNDERGROUND WORKS
Drawing No	DESCRIPTION

REFERENCE DRAWINGS

CONFIDENTIAL

[illegible]RDCG (Rotterdam Capacity Growth) - FEASIBILITY PHASE
NESTE

MAJOR UNDERGROUND & PIPING LAYOUT MNA AREA - PART 1

Scale	Technip Drawing No						Page	Rev.
1/750	082755C	000	DW	14	42	0001	2of4	A
	Project	Unit	Doc.Type	Disc	Subj	Ser.No		

NESTE Drawing No