
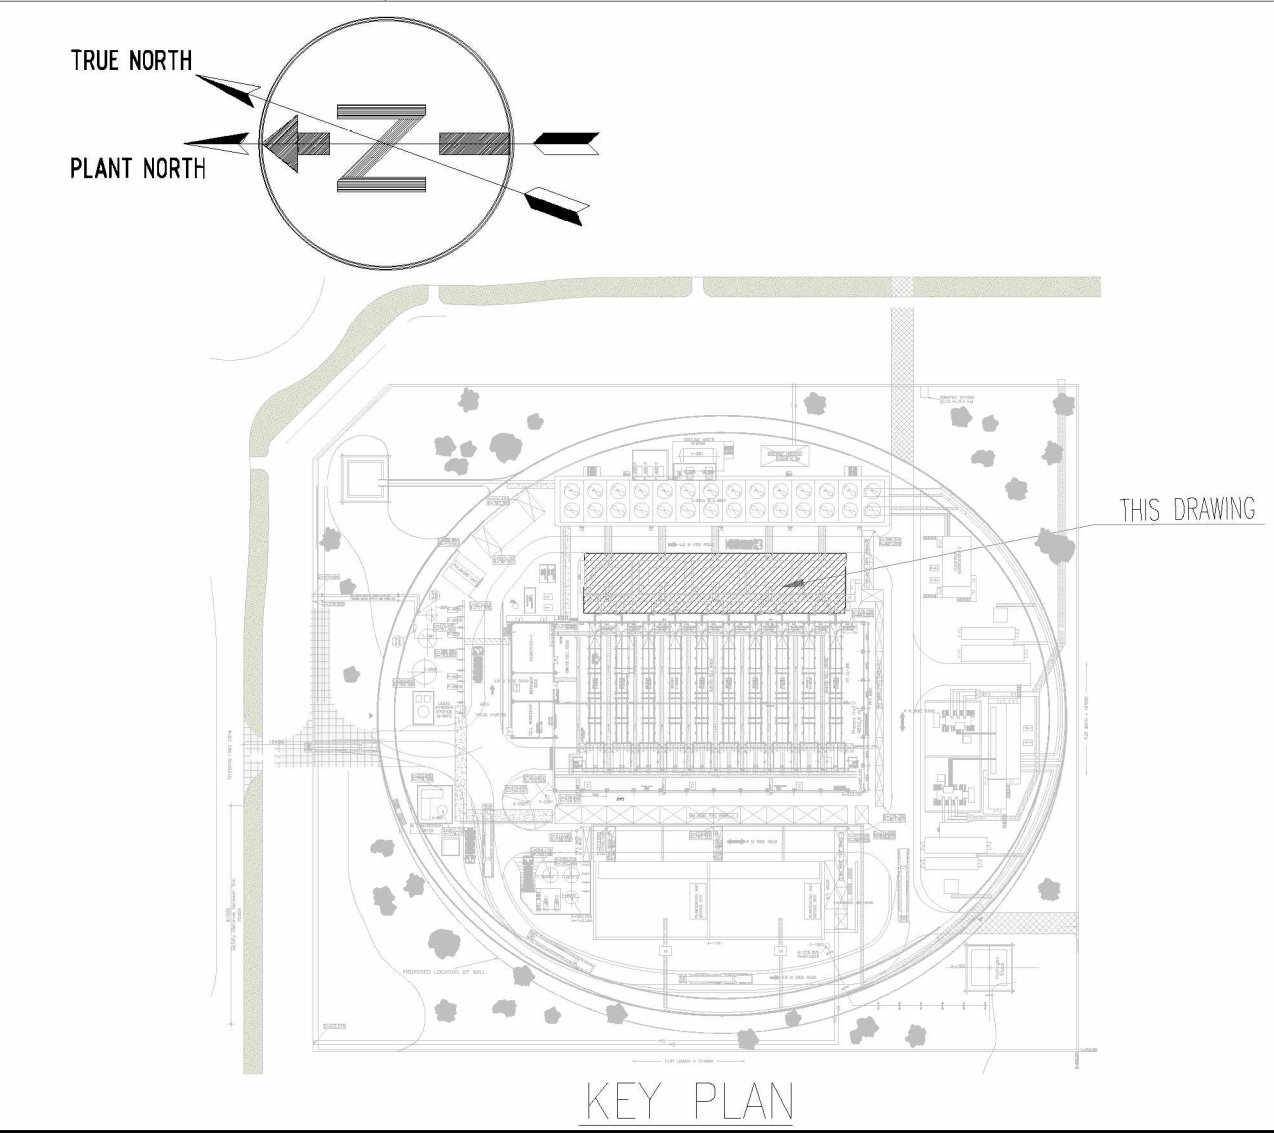


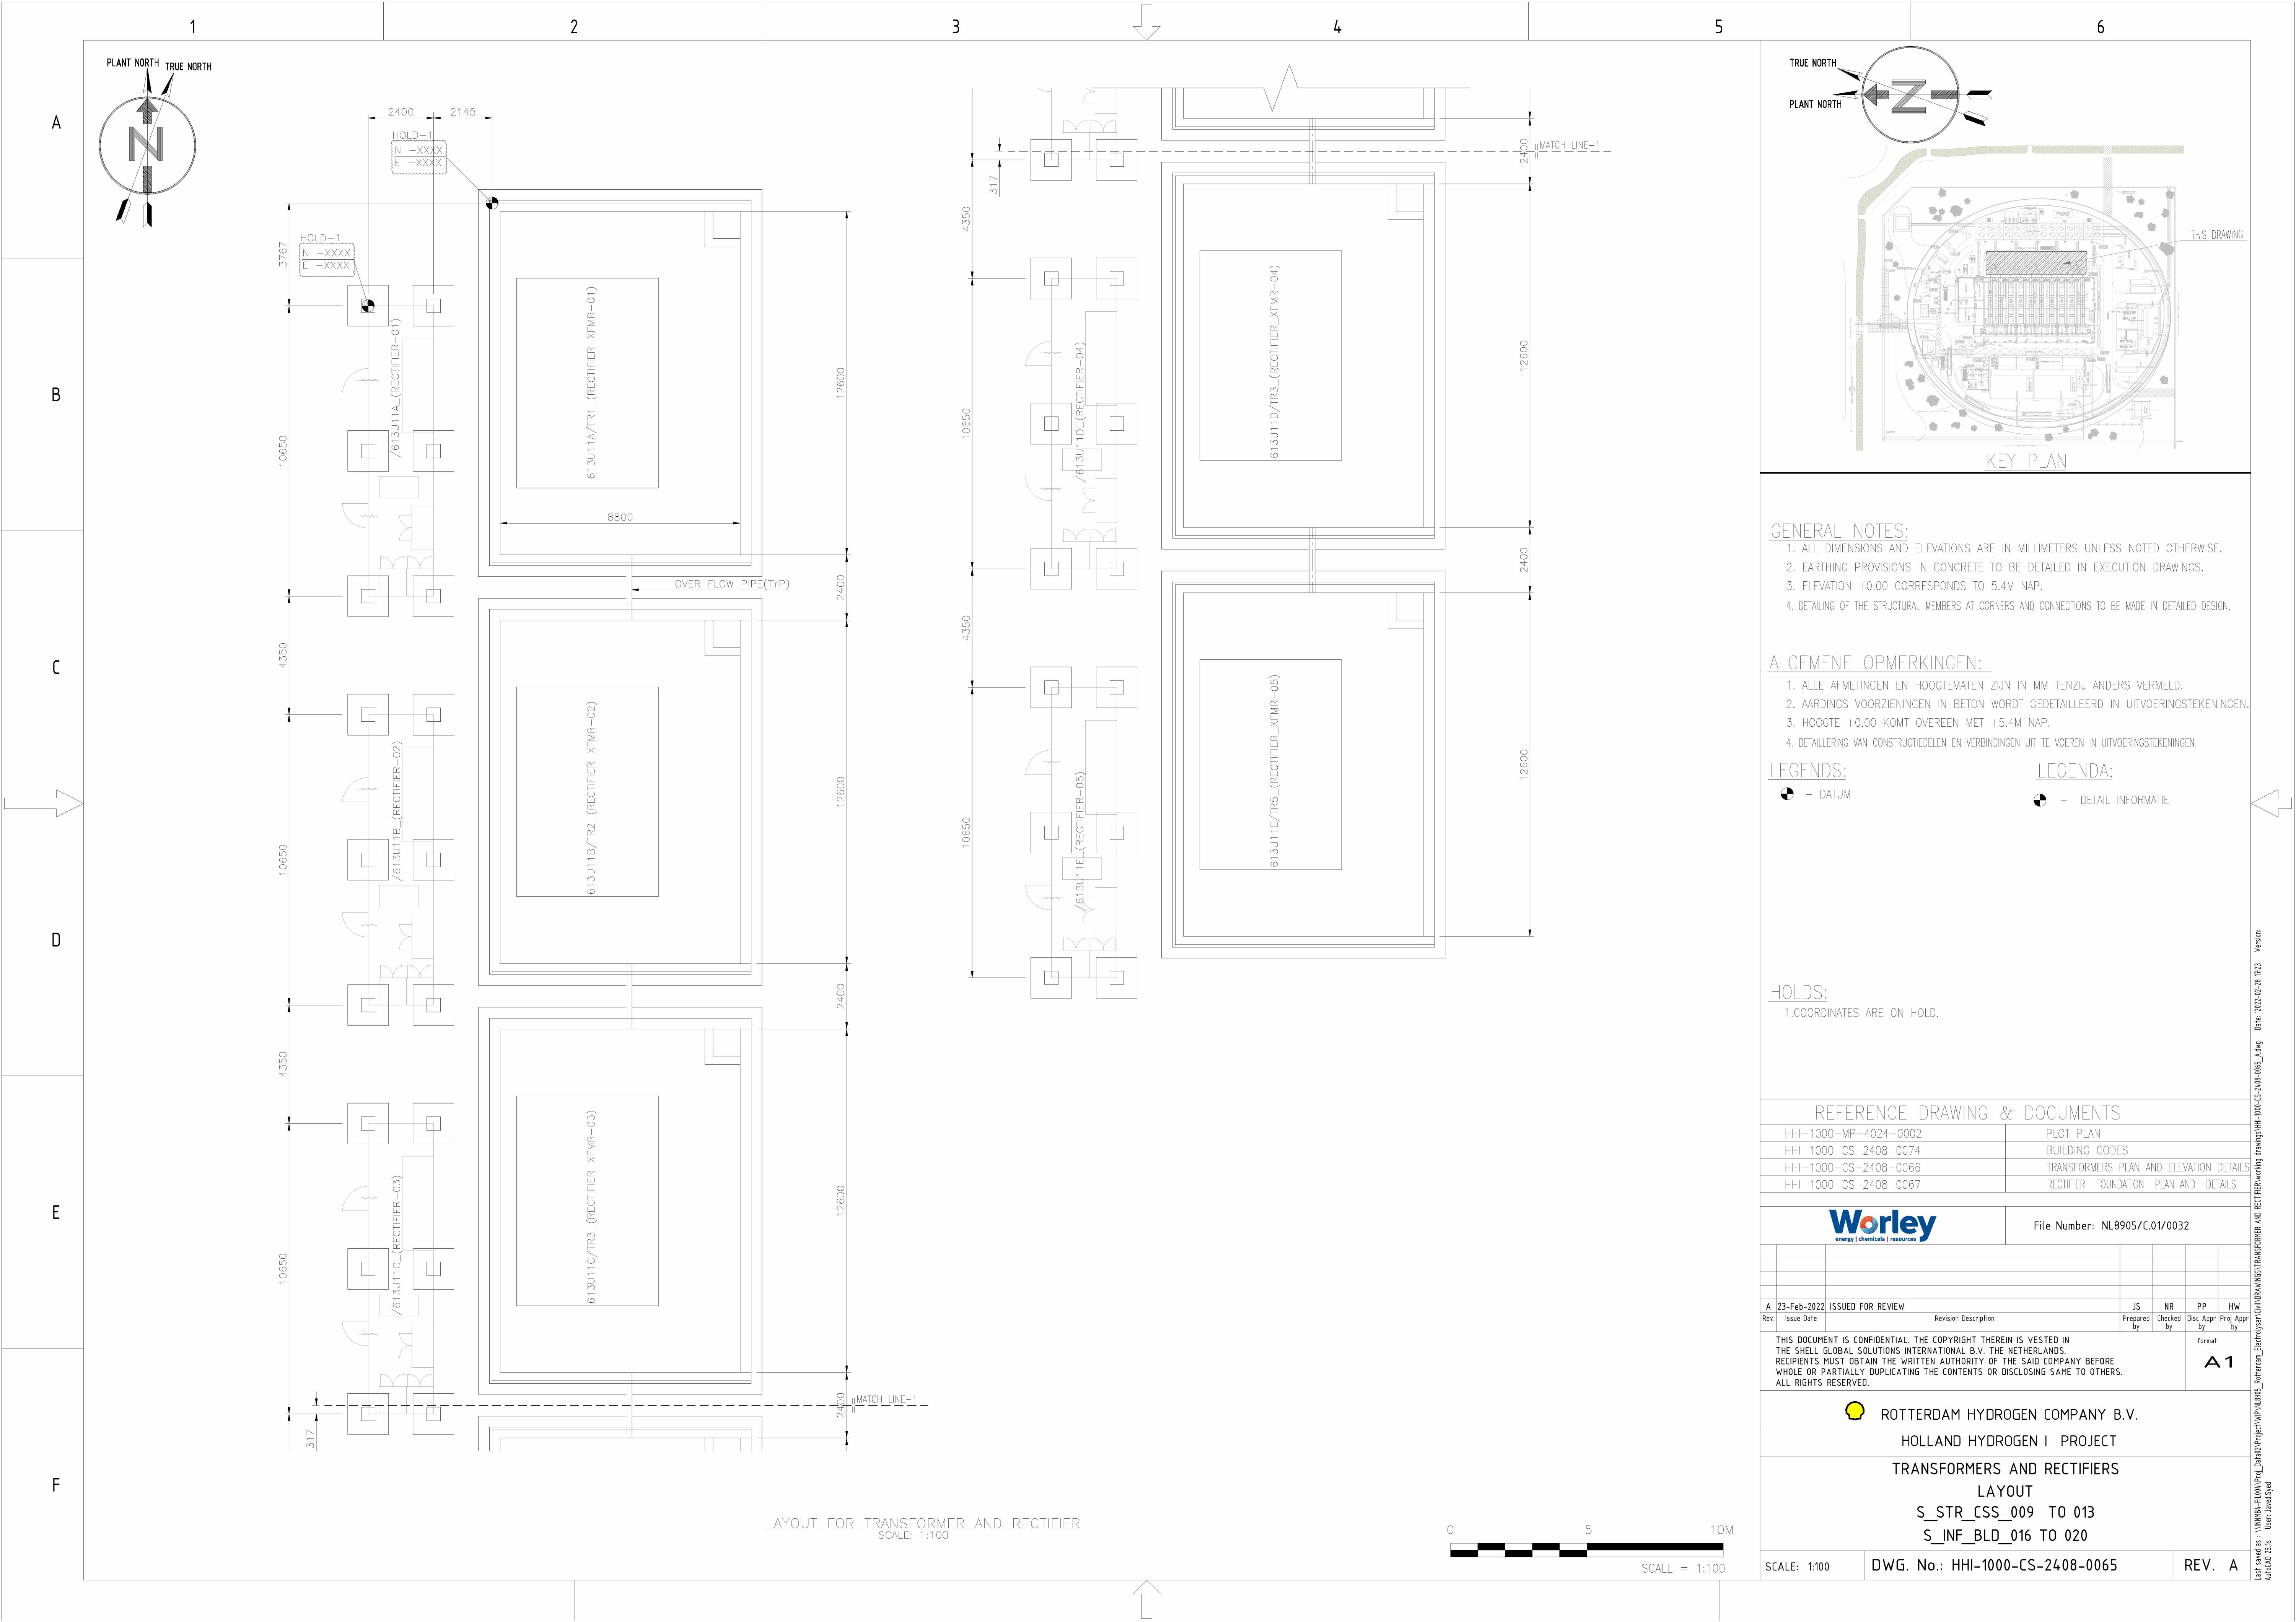

- GENERAL NOTES:**
1. ALL DIMENSIONS AND ELEVATIONS ARE IN MILLIMETERS UNLESS NOTED OTHERWISE.
 2. EARTHING PROVISIONS IN CONCRETE TO BE DETAILED IN EXECUTION DRAWINGS.
 3. ELEVATION +0.00 CORRESPONDS TO 5.4M NAP.
 4. DETAILING OF THE STRUCTURAL MEMBERS AT CORNERS AND CONNECTIONS TO BE MADE IN DETAILED DESIGN.

- ALGEMENE OPMERKINGEN:**
1. ALLE AFMETINGEN EN HOOGTEMATEN ZIJN IN MM TENZIJ ANDERS VERMELD.
 2. AARDINGS VOORZIENINGEN IN BETON WORDT GEDETAILLEERD IN UITVOERINGSTEKENINGEN.
 3. HOOGTE +0.00 KOMT OVEREEN MET +5.4M NAP.
 4. DETAILERING VAN CONSTRUCTIEDELEN EN VERBINDINGEN UIT TE VOEREN IN UITVOERINGSTEKENINGEN.

- LEGENDS:**
- - DATUM
 - - DETAIL INFORMATIE

- HOLDS:**
- 1.COORDINATES ARE ON HOLD.

REFERENCE DRAWING & DOCUMENTS	
HHI-1000-MP-4024-0002	PLOT PLAN
HHI-1000-CS-2408-0074	BUILDING CODES
HHI-1000-CS-2408-0066	TRANSFORMERS PLAN AND ELEVATION DETAILS
HHI-1000-CS-2408-0067	RECTIFIER FOUNDATION PLAN AND DETAILS

Worley energy chemicals resources		File Number: NL8905/C.01/0032			
A 23-Feb-2022 ISSUED FOR REVIEW		JS	NR	PP	HW
Rev.	Issue Date	Prepared by	Checked by	Disc. Appr. by	Prog. Appr. by
THIS DOCUMENT IS CONFIDENTIAL. THE COPYRIGHT THEREIN IS VESTED IN THE SHELL GLOBAL SOLUTIONS INTERNATIONAL B.V. THE NETHERLANDS. RECIPIENTS MUST OBTAIN THE WRITTEN AUTHORITY OF THE SAID COMPANY BEFORE WHOLE OR PARTIALLY DUPLICATING THE CONTENTS OR DISCLOSING SAME TO OTHERS. ALL RIGHTS RESERVED.					format A1

ROTTERDAM HYDROGEN COMPANY B.V.	
HOLLAND HYDROGEN I PROJECT	
TRANSFORMERS AND RECTIFIERS LAYOUT	
S_STR_CSS_009 TO 013	
S_INF_BLD_016 TO 020	
SCALE: 1:100	DWG. No.: HHI-1000-CS-2408-0065
REV. A	

Left saved as: \\VW064-FILE004-Proj_Datad0-Project\MP-NL8905_Rotterdam_Electrolyser\Civil\DRAWINGS\TRANSFORMERS AND RECTIFIER\working drawing\HHI-1000-CS-2408-0065_4.dwg Date: 2022-02-28 17:23 Version: AutoCAD 2013 User: Javed.Syed