

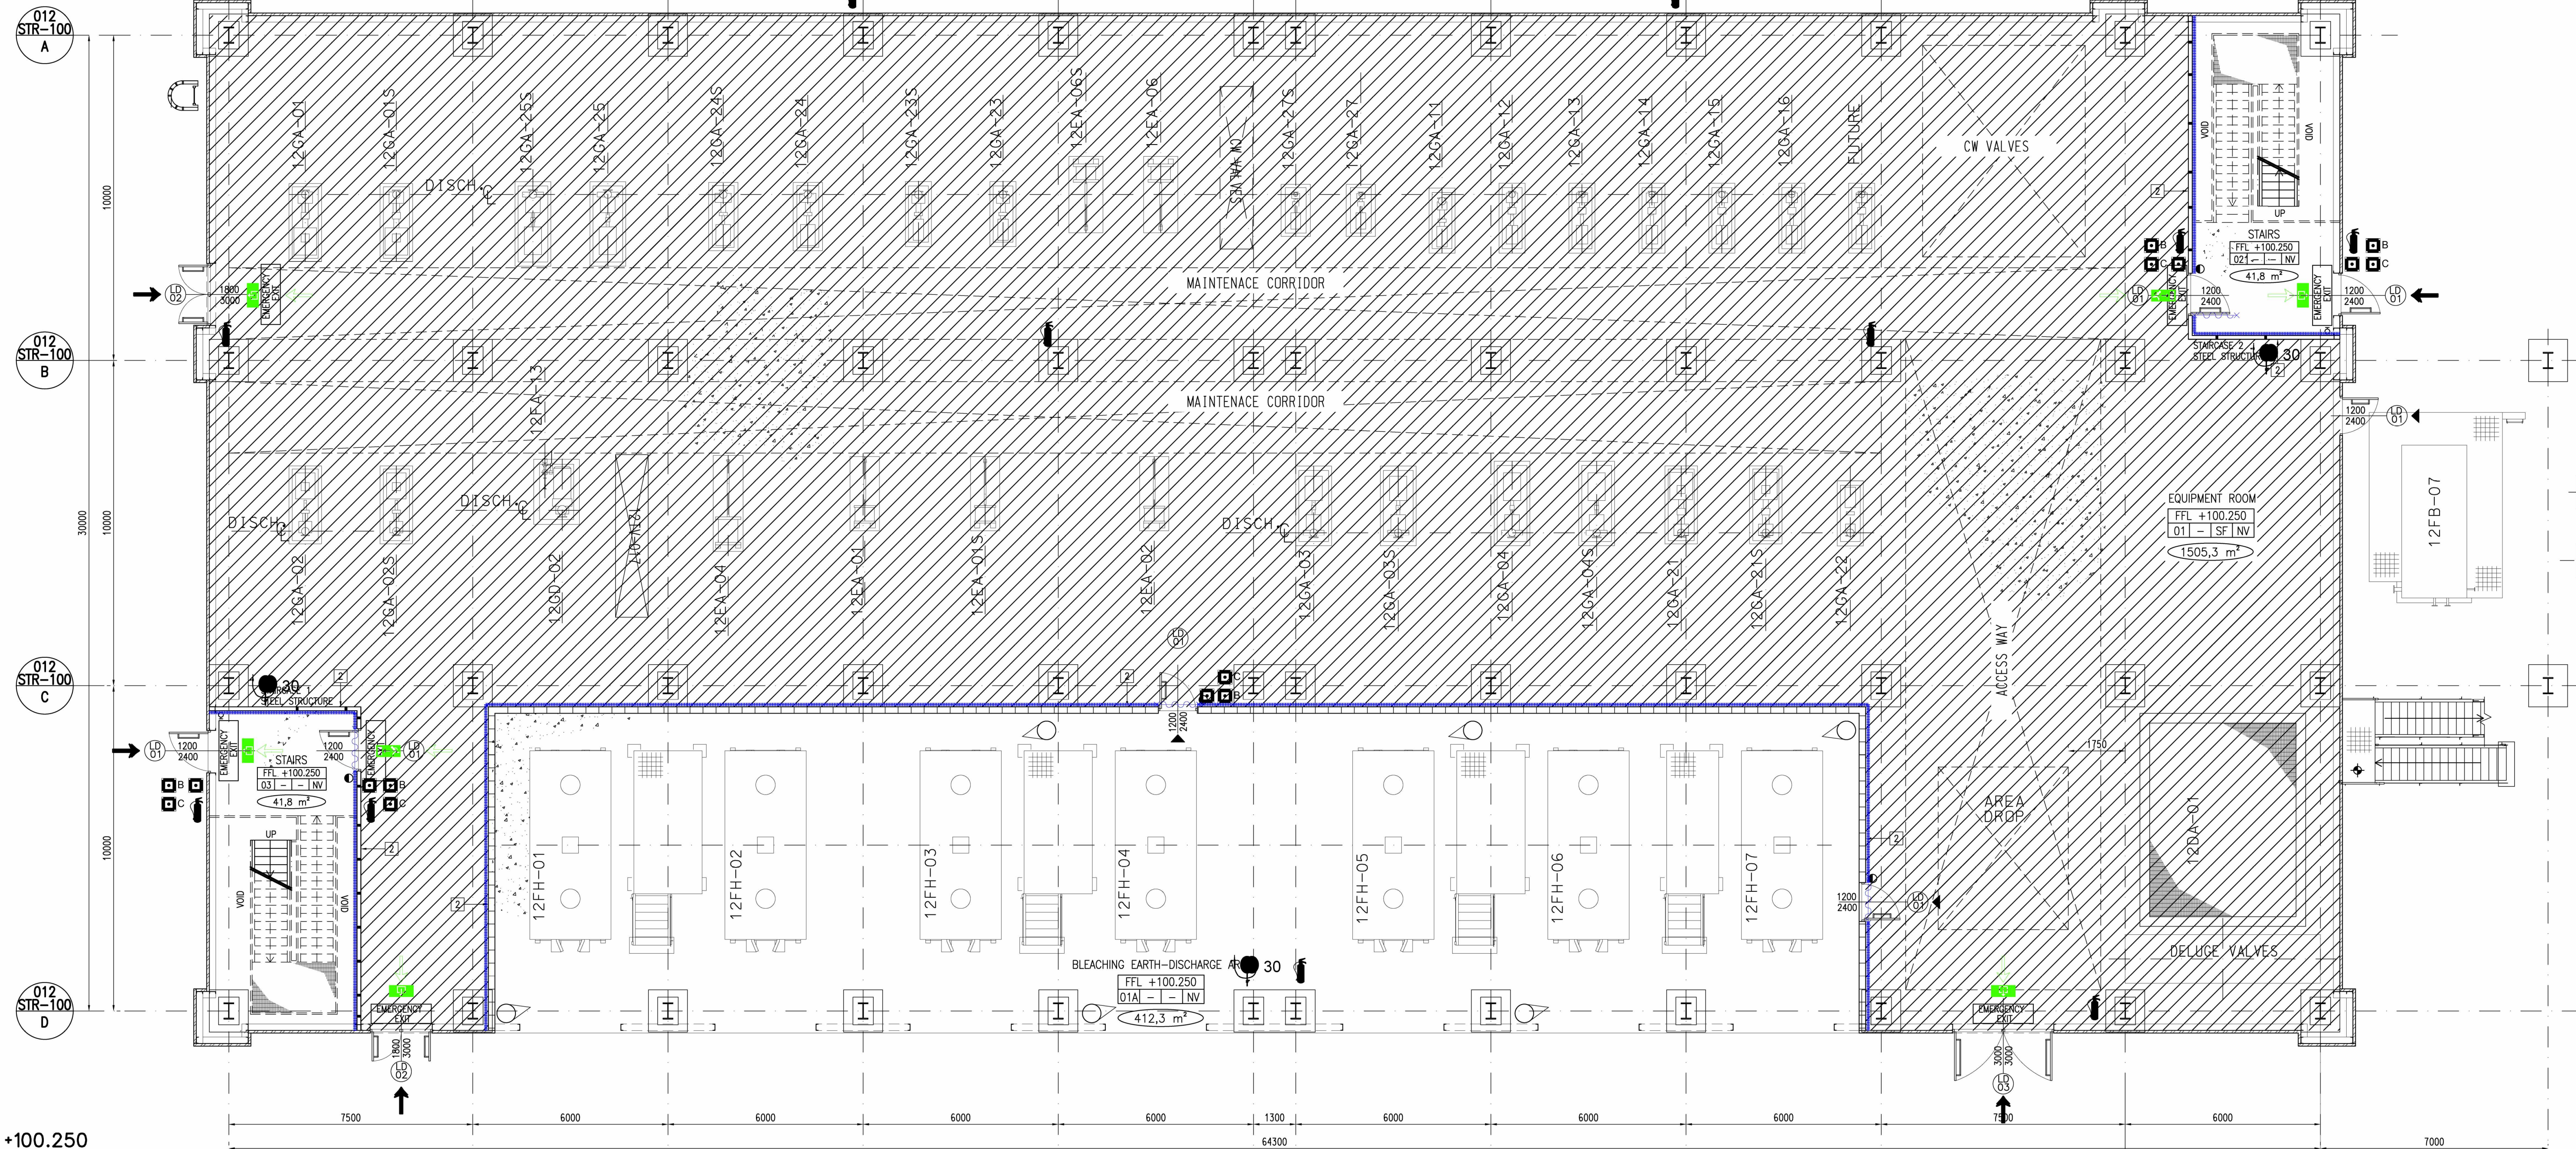


The present document or drawing is property of TECHNIP ITALY S.p.A. and shall not, under any circumstances, be totally or partially directly or indirectly, transferred, reproduced, copied, disclosed or used, without its prior written consent, for any purpose and in any way other than that for which it is specifically furnished or outside the extent of the agreed upon right of use.

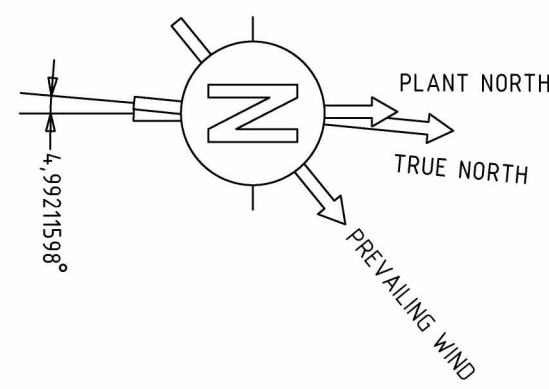

PLAN AT ELEV. +100.250

1st STOREY

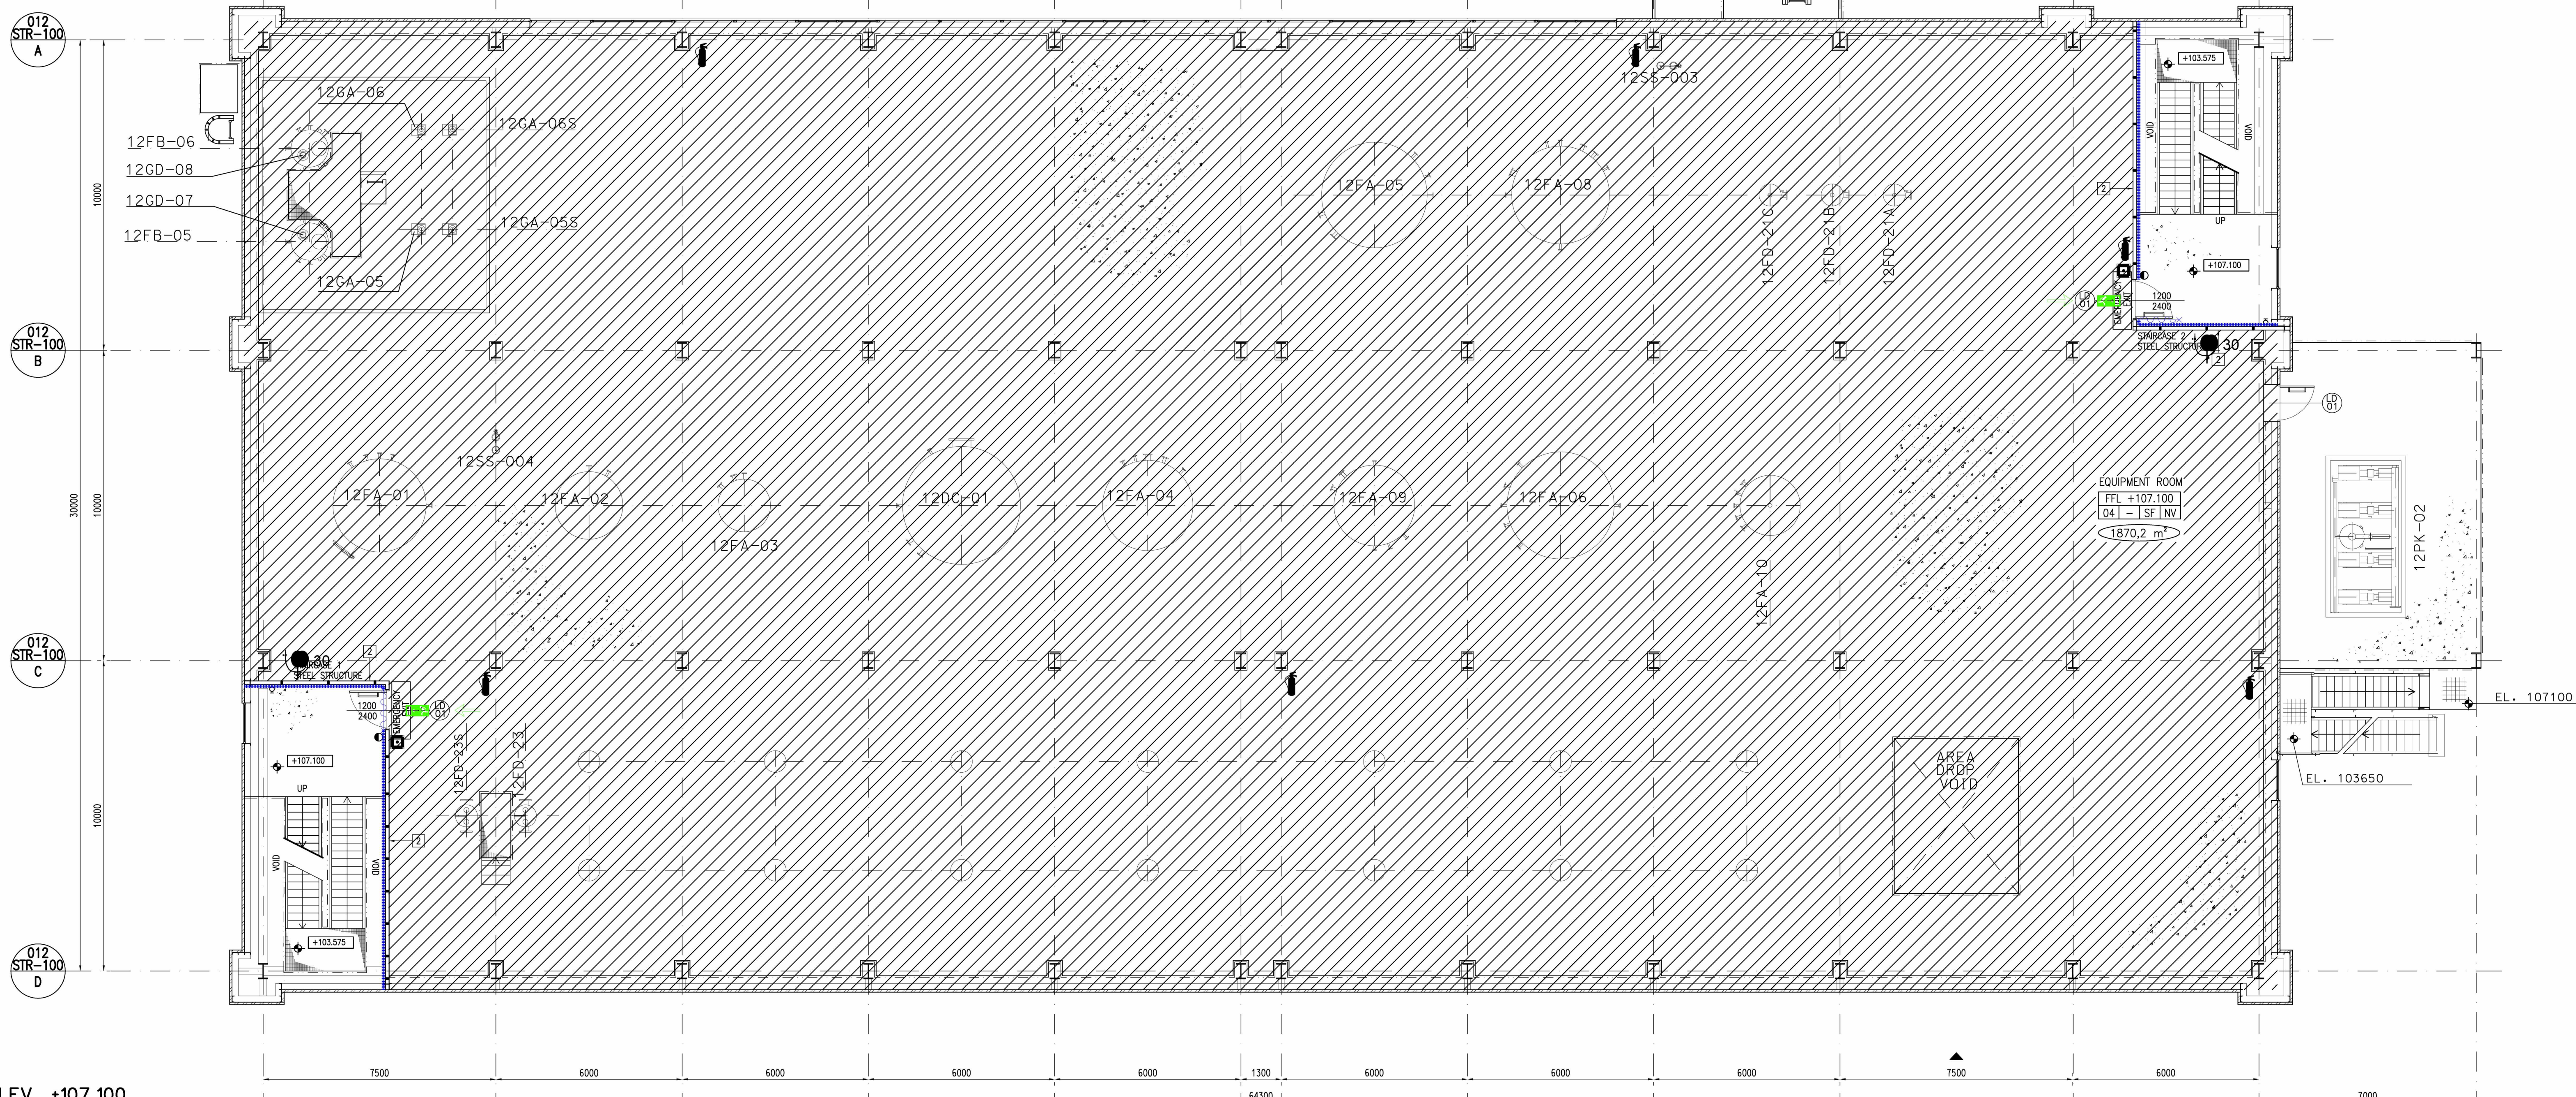

PLAN AT ELEV. +107.100


2nd STOREY

GENERAL NOTES

- SEE SH-1
- THIS DRAWING IS VALID ONLY FOR SUBCONTRACTOR SYSTEM AND FINISHING DETAILED DESIGN. MATERIAL SELECTION AND FOR BUILDING PERMIT.
- THE STAIRCASES SHALL BE PROVIDED OF EMERGENCY LIGHTING.
- FOR APPLICABLE FIRE AND SMOKE CLASSES PLEASE REFER TO THE "INTEGRAL PLAN BRANDBEVEILIGHEID".
- IN-ROOM DETECTION SYSTEMS SHALL BE EQUIPPED WITH AN ACUSTIC AND OPTICAL SIGNALLING SYSTEM.
- POSITION OF FIRE HYDRANTS IN GENERAL SITE SHALL BE CHECKED.

LEGEND

TEKENSYMBOLLEN	
Symbol	Beschrijving
	Vluchtwegaanduiding conform NEN 6088, deuren uitvoeren als vluchtdoor
	Nooduitgang, deuren uitvoeren als vluchtdoor
	Brandwerendheid ten minste 30 minuten WBDO
	Brandwerendheid ten minste 50 minuten WBDO
	Brandwerendheid ten minste 120 minuten WBDO
	Brandwerendheid en zelfsluitende deur, 30 minuten WBDO
	Brandwerendheid en zelfsluitende deur, 60 minuten WBDO
	Brandwerendheid en zelfsluitende deur, 120 minuten WBDO
	Slanghaspel, slanglengte van 30 meter conform NEN-EN 610-1 deel 1 tot 3
	Draagbaar blusmiddel (spiroeschum)
	Draagbaar blusmiddel op wielen (spiroeschum)
	Handbrandmelder
	Brandalarmbaken (rood)
	Brandalarm dixon
	Vlamdetector uitr type
	Rook afzuigkap
	Bezettingsgraadklasse
	Ruimte voorzien van automatische brandmelders
	Brandweeringang
	Vluchtroute

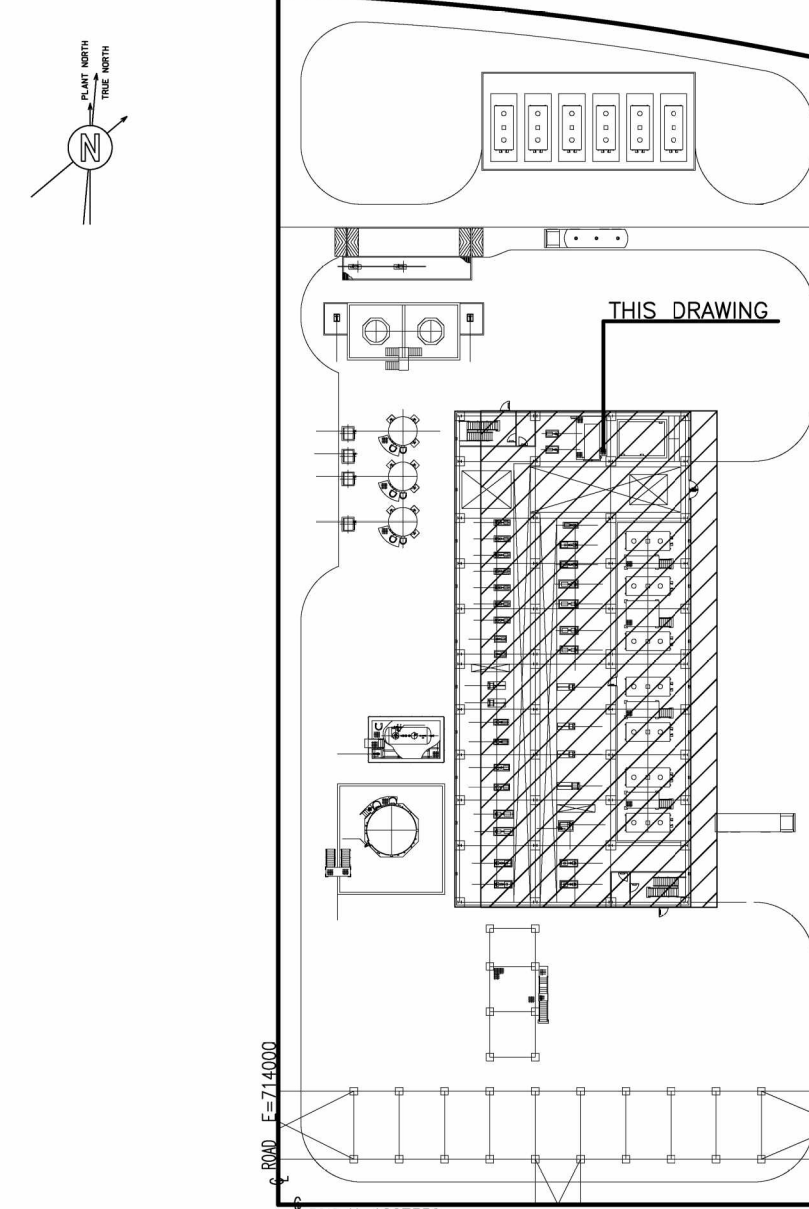

082755C-12-DW-0001-003	12 (PTU) UNIT PLOT PLAN
Drawing No	DESCRIPTION

REFERENCE DRAWINGS

CONFIDENTIAL					
B	05/06/2021	ISSUED FOR LOCAL AUTHORITIES	P.FIORELLI	VERBORGEN WAPEN M.CALPINI	V.COLOMBO M.LANDOTTI
A	24/06/2021	ISSUED FOR FEED (DEFINITION PHASE)	S.TRUJEN	M.CALPINI	V.COLOMBO M.LANDOTTI
REV	DATE	DESCRIPTION	PREP	CKD	APPR/AUTH

NESTE

TECHNIP ENERGIES

RDCG (Rotterdam Capacity Growth) - DEFINITION PHASE

NESTE

GENERAL DRAWINGS FOR PTU STRUCTURE

EMERGENCY ESCAPE ROUTE AND FIRE PROTECTION LAYOUT

Scale	Technip Drawing No	Page	Rev.
1:100	082755C 012 DW 18 01 0001	11of13	B

NESTE Drawing No

CAD Model