



The present document or drawing is property of TECHNIP ITALY S.p.A. and shall not, under any circumstances, be totally or partially directly or indirectly transferred, reproduced, copied, disclosed or used, without its prior written consent, for any purpose and in any way other than that for which it is specifically furnished or outside the extent of the agreed upon right of use.

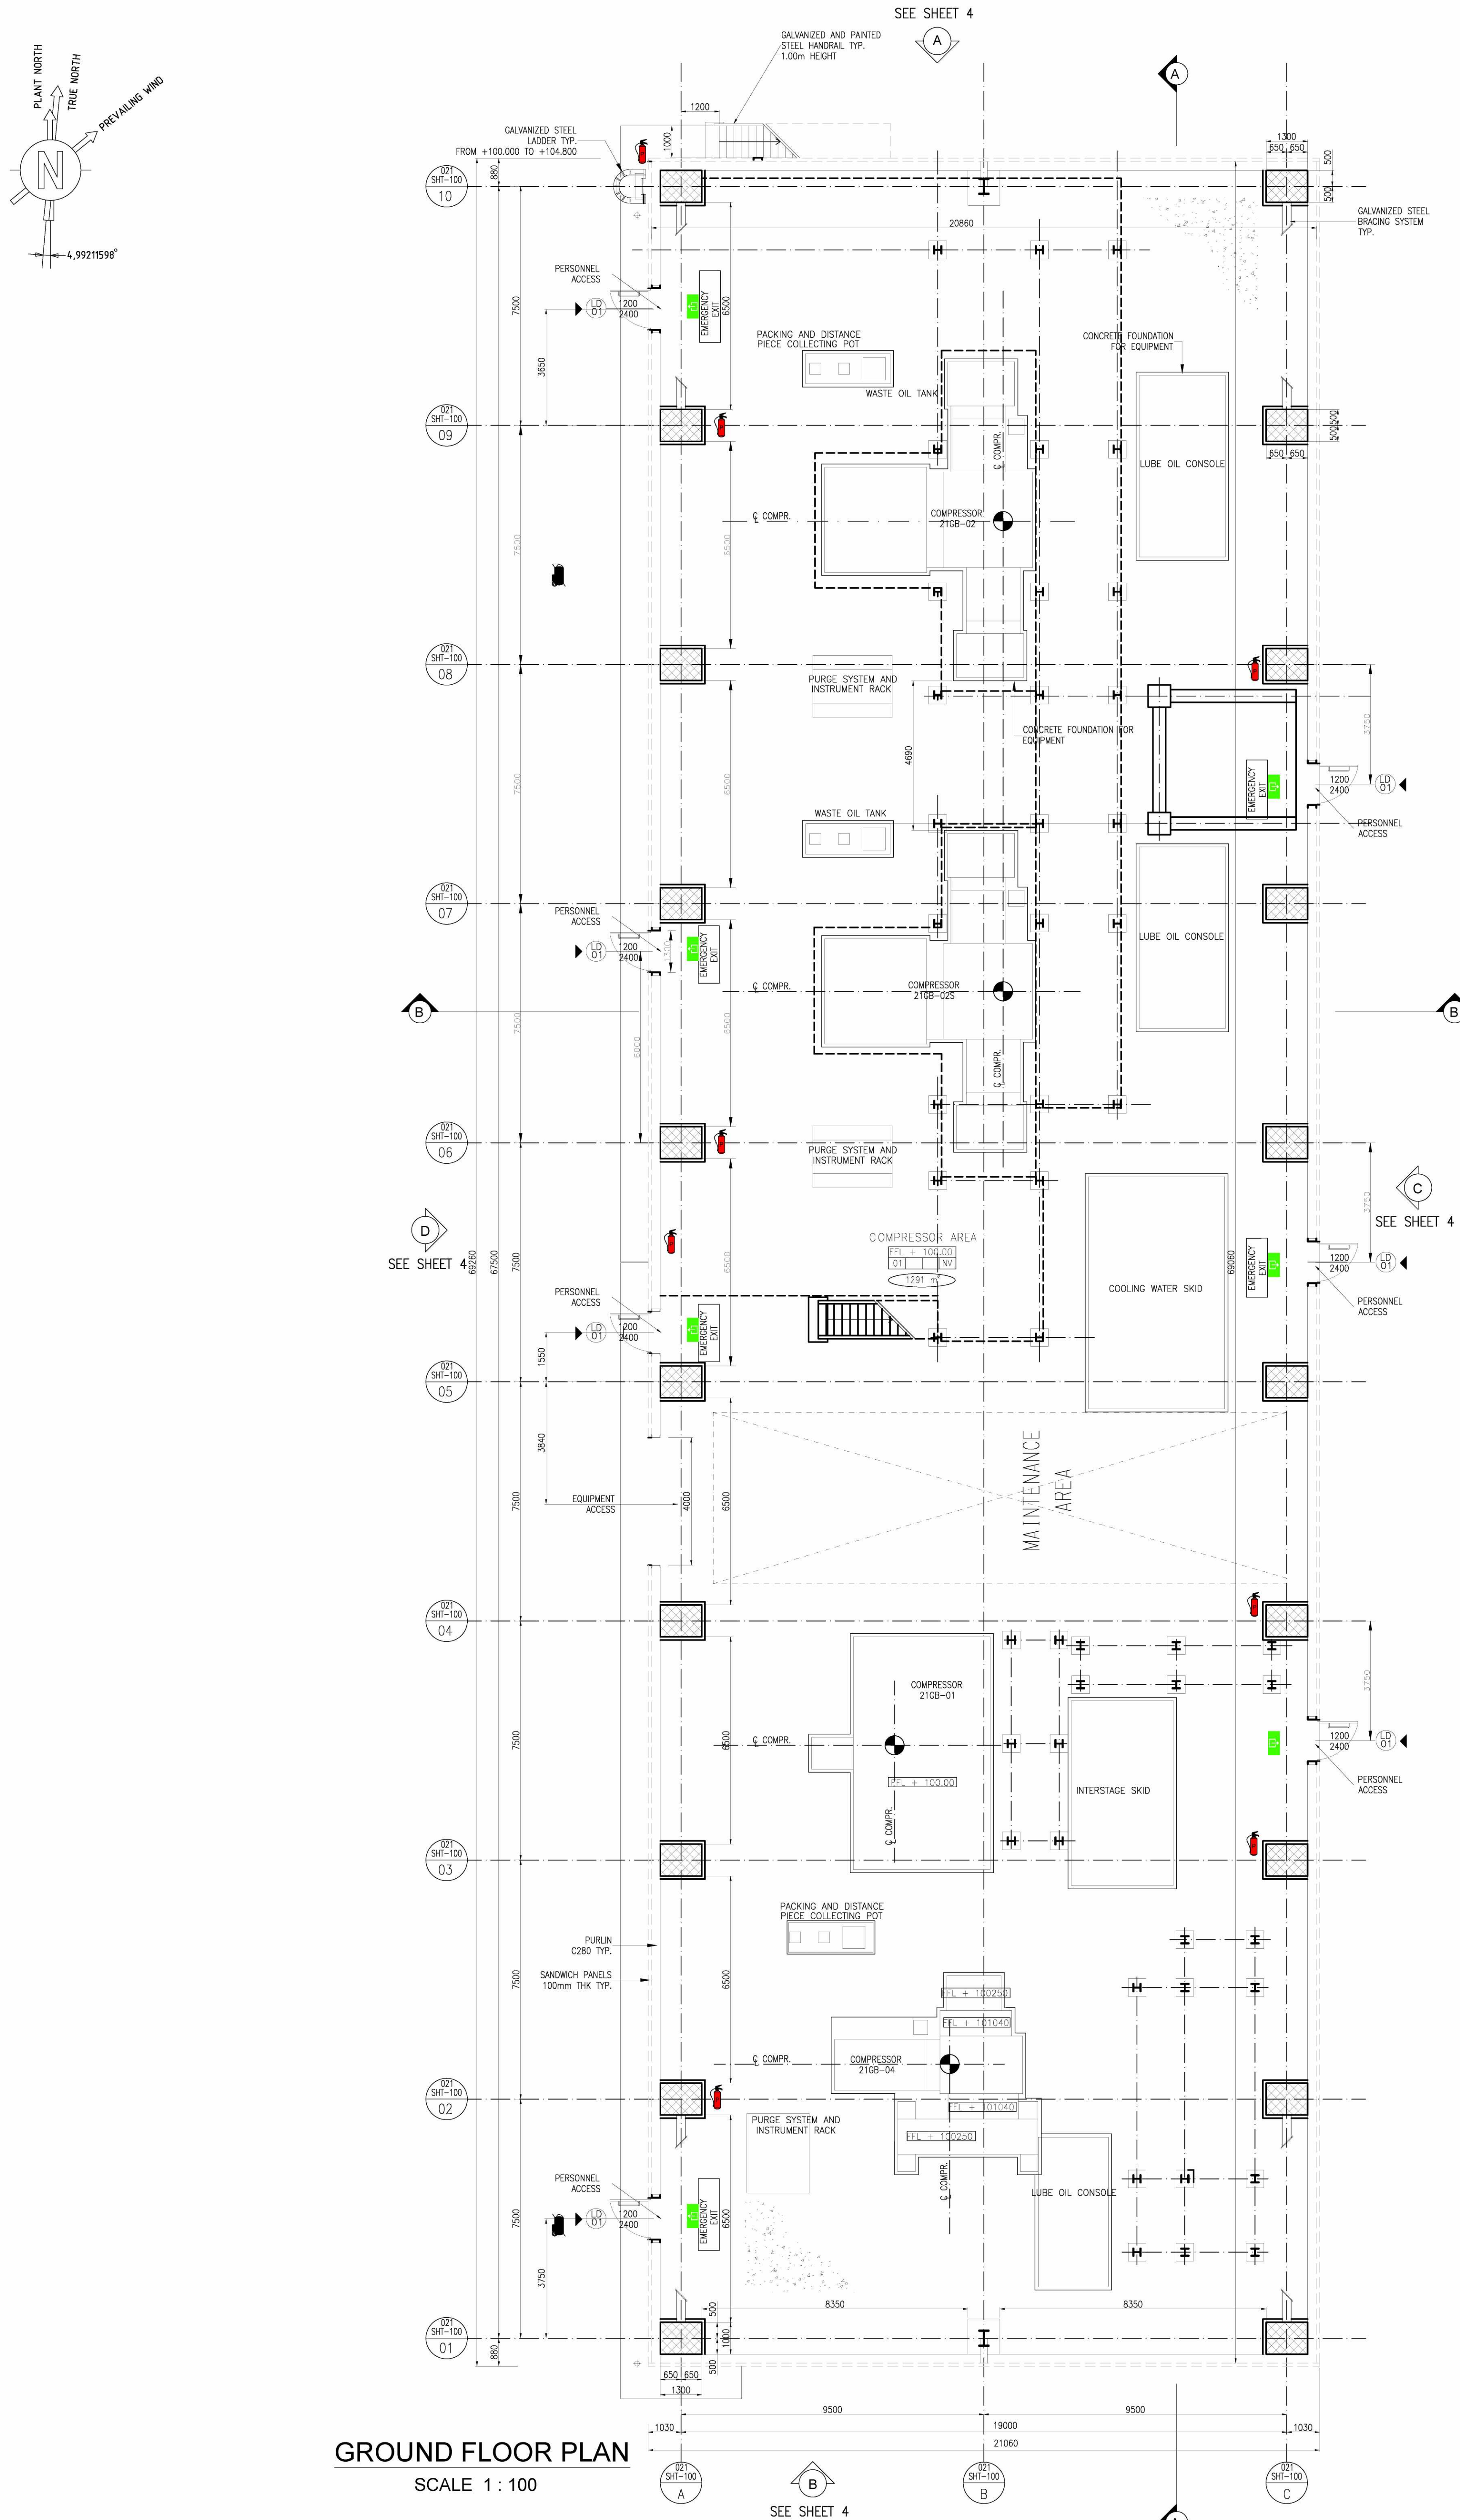

GROUND FLOOR PLAN
SCALE 1 : 100

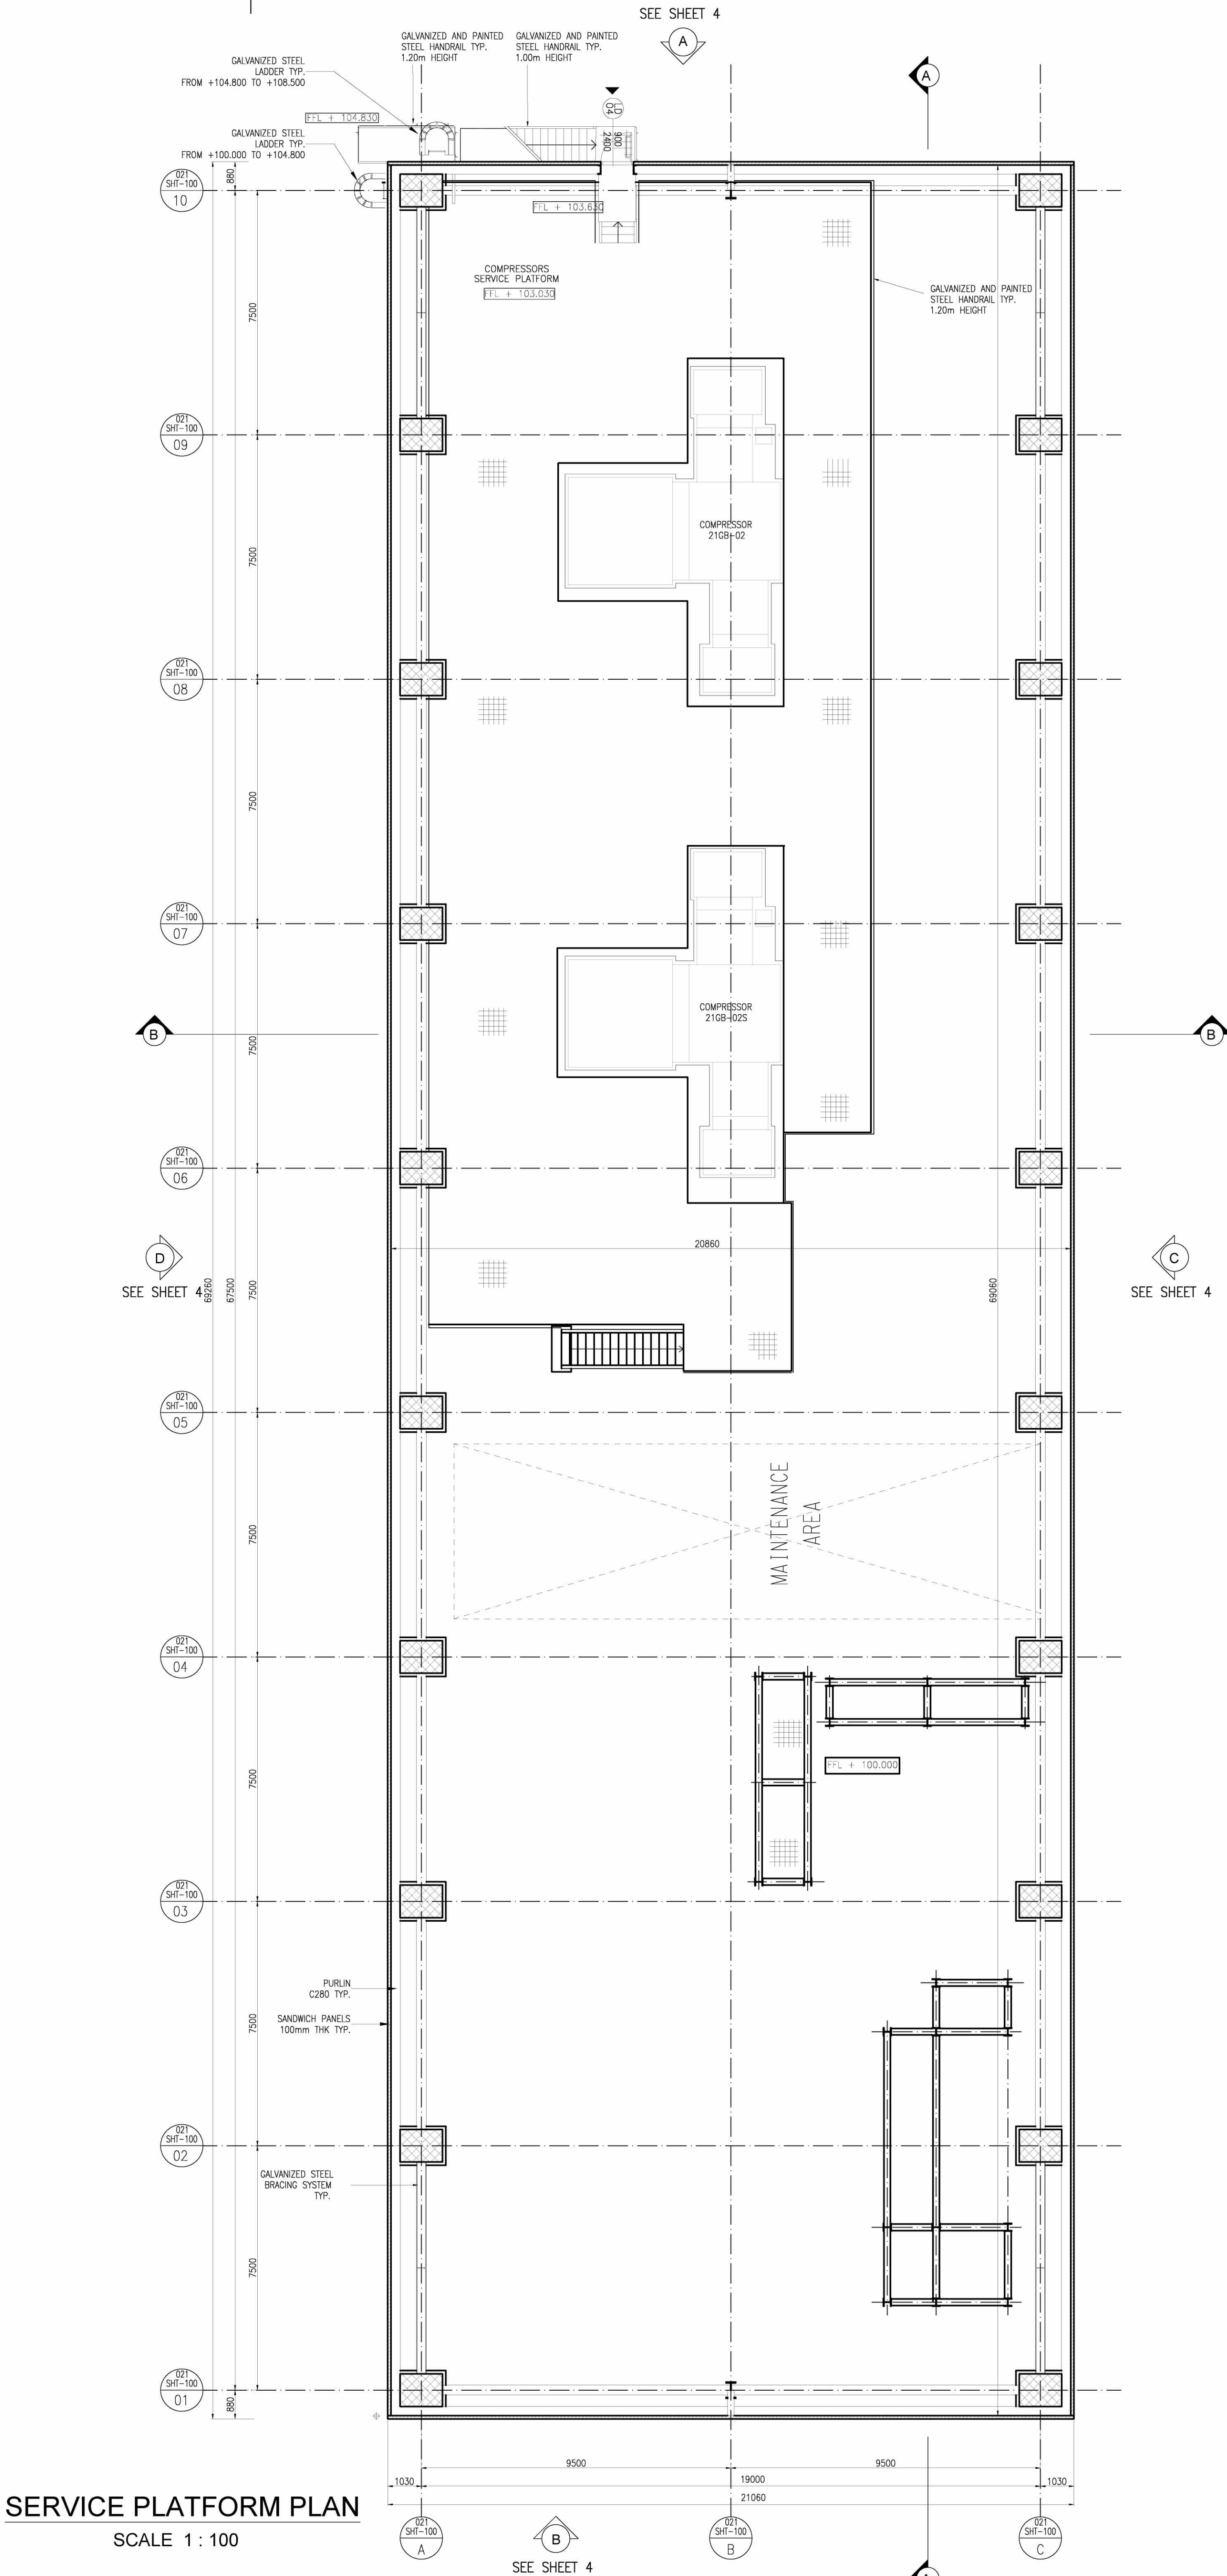

SERVICE PLATFORM PLAN
SCALE 1 : 100

GENERAL NOTES

- COORDINATES ARE REFERRED TO PLANT NORTH.
PLANT REFERENCE POINT (N=1000.000 AND E=1000.000)
CORRESPONDS TO GEOGRAPHIC COORDINATES (N=443433.61/E=60602.33)
- ALL DIMENSIONS AND ELEVATIONS ARE IN MILLIMETERS AND 360° DEGREES CIRCLE UNLESS OTHERWISE INDICATED.
- ALL COORDINATES ARE IN METERS.
- THE ELEVATION 100.00 CORRESPONDS TO (HIGH POINT OF PAVING) AND IS EQUIVALENT +5.80m. A.S.P.
- THIS DRAWING IS VALID ONLY FOR SUBCONTRACTOR SYSTEM AND FINISHING DETAILED DESIGN, MATERIAL SELECTION AND FOR BUILDING PERMIT.
- THE STAIRCASES SHALL BE PROVIDED OF EMERGENCY LIGHTING.
- FOR APPLICABLE FIRE AND SMOKE CLASSES PLEASE REFER TO THE "INTEGRAL PLAN BRANDBEVEILIGED".
- IN-ROOM DETECTION SYSTEM SHALL BE EQUIPPED WITH AN ACOUSTIC AND OPTICAL SIGNALLING SYSTEM.
- POSITION OF FIRE HYDRANTS IN GENERAL SITE SHALL BE CHECKED.

LEGEND

TEKENSYMBOLEN	omschrijving
	Vluchtwegafsluiting conform NEN 6088, deuren uitvoeren als vluchdeur
	Nooduitgang, deuren uitvoeren als vluchdeur
	Brandwerendheid ten minste 30 minuten
	Brandwerendheid ten minste 60 minuten
	Brandwerendheid ten minste 120 minuten
	Brandwerendheid en zelfsluitende deur, 30 minuten WBDBO
	Brandwerendheid en zelfsluitende deur, 60 minuten WBDBO
	Brandwerendheid en zelfsluitende deur, 120 minuten WBDBO
	Slanghaspel, slanglengte van 30 meter conform NEN-EN 670 blad 1 t/m 3
	Draagbaar blusmiddel op wielen (sproeischuim)
	Draagbaar blusmiddel op wielen (sproeischuim)
	Handbrandmelder
	Brandmelderbaken (rood)
	Brandalarm claxon
	Vlamdetector uv/ir type
	Rook afzuigkap
	Bezettingsgraadklasse
	Ruimte voorzien van automatische brandmelders en een blusgasinstallatie
	Brandweeringang
	Vluchtroute

GENERAL PLOT PLAN

THIS DRAWING

KEY PLAN

021 (NEXTBTL) - UNIT PLOT PLAN ELEVATION

021 (NEXTBTL) - UNIT PLOT PLAN ELEVATION

021 (NEXTBTL) - UNIT PLOT PLAN

DESCRIPTION

REFERENCE DRAWINGS

CONFIDENTIAL

REV	DATE	DESCRIPTION	PREP	CKD	APPR/AUTH
B	10-08-2021	ISSUED FOR LOCAL AUTHORITY	A.DEEVSKA	E.BROOKAMP	V.COLOONE
A	28/07/2021	ISSUED FOR REVIEW	C.BRACHIDOLI	M.CALPINI	V.COLOONE

NESTE

TEN

RDCG (Rotterdam Capacity Growth) - DEFINITION PHASE

NESTE

GENERAL LAYOUT DRAWINGS FOR 021-SHT-100 COMPRESSOR SHELTER

EMERGENCY ESCAPE ROUTE AND FIRE PROTECTION LAYOUT

GROUND FLOOR AND FIRST FLOOR PLANS

Scale	Technip Drawing No	Page	Rev.
1:100	082755C 021 DW 18 01 0001	6	B

NESTE Drawing No

CAD Model

AD 1183x841

TECHNIP ITALY S.p.A. - 00148 ROMA - Viale Castello della Magliana, 68

CAD Model 082755C-021-DW-1801-0001-06_B.dwg