


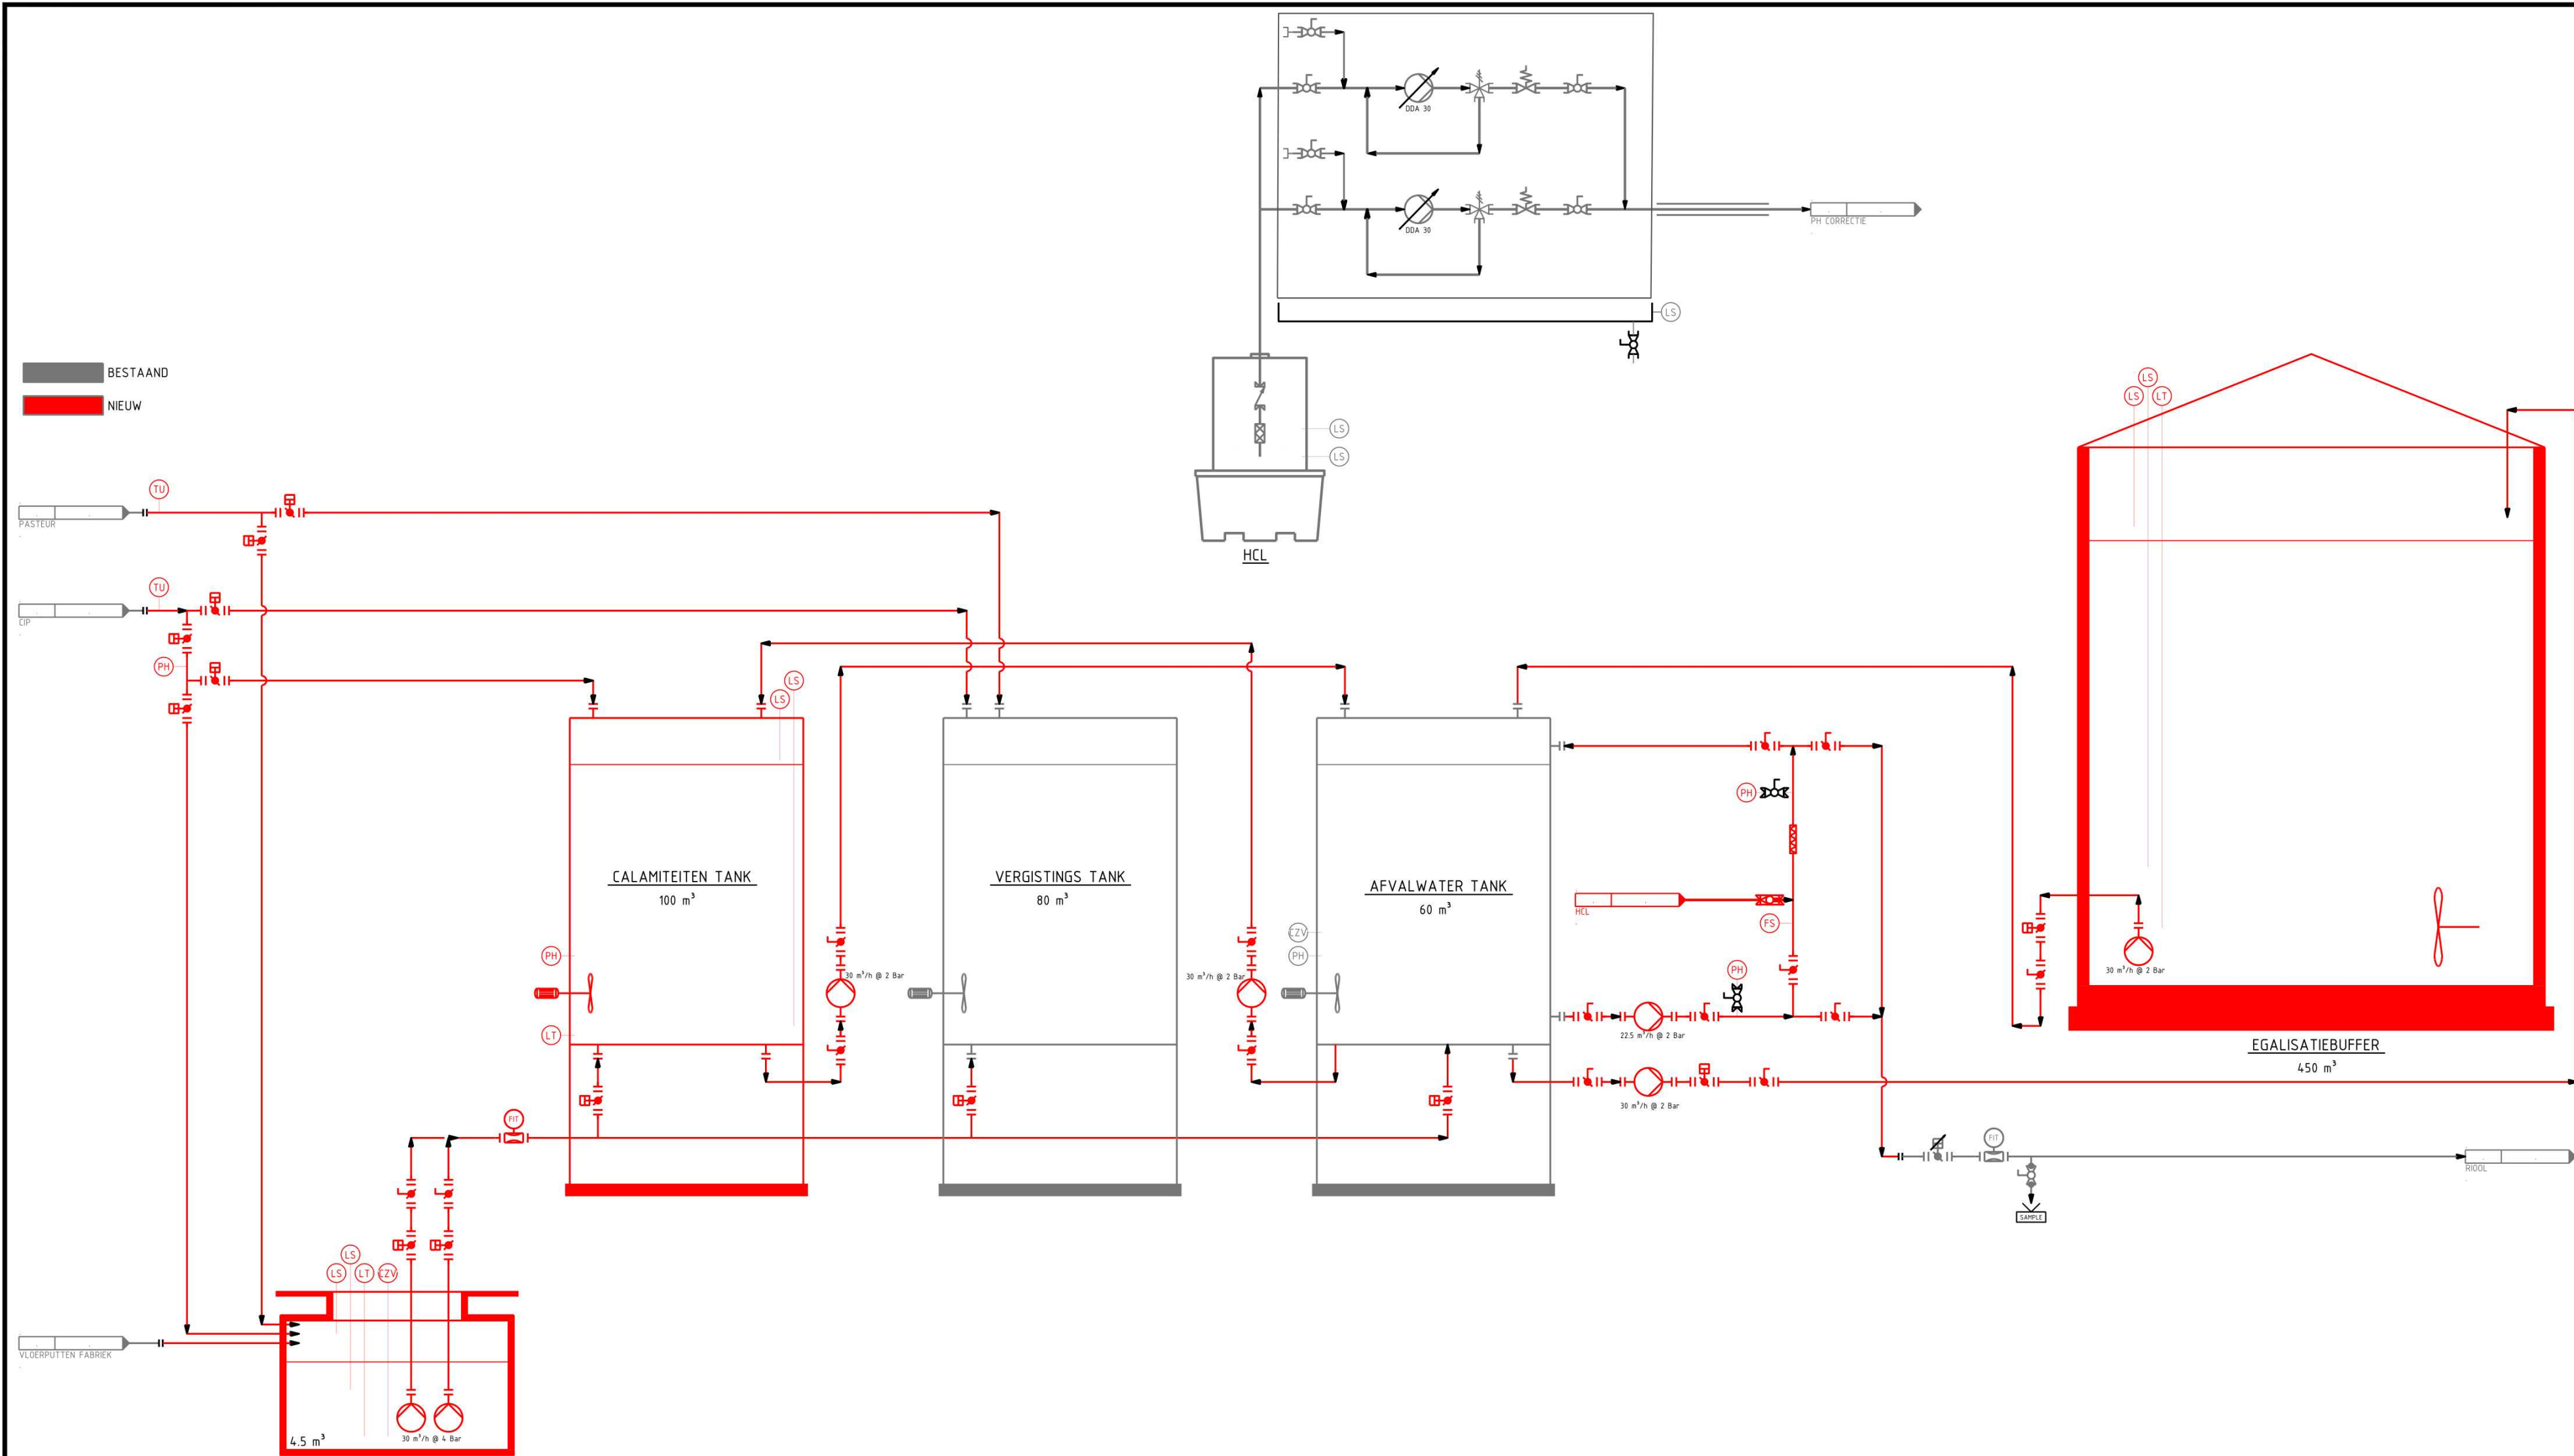

01	INITIAL ISSUE	SRO	----	----	18/02/2026
Issue	Description	Drawn by	Checked	Approved	Date
 Egide Walschaertsstraat 22L 2800 Mechelen - Belgium Tel: +32(0)15 424 774 - info@pantarein.be http://www.pantareinwater.be					
Klant		State			
VECO		WORK IN PROGRESS			
		Format			
		A2			
Titel		Project			
P&ID		25106			
WWTP		Drawing		Issue	
		25106_1010		01 a	