



Aldgate House
33 Aldgate High Street
London EC3N 1AH
United Kingdom
Tel. +44 (0)20 7073 9600



AGRIPORT 570
1775TB MIDDENMEER
THE NETHERLANDS

Design Team

Design	GENSLER
Drawn	GARY SCHOFIELD
Checked	19.02.15
Date	R1559
Company Project No.	P13262
M.S. Project No.	

Approvals

CUSTOMER	DATE
MICROSOFT	
BRYAN ANDERSEN	
Microsoft Mechanical Engineer	DATE
CARLOS OLARIBO	
Microsoft Cable Engineer	
STEVE STEINERT	
Microsoft Electrical Engineer	
DREW REEVES	
Engineering Manager	
MICHAEL WATERS	
Security Manager	
JOHN PERSONS	
CSA	

PROJECT MANAGEMENT


Project Planner	Date
Project Manager	
Senior Project Manager	
Development Manager	
Project Manager	
Quality Control Reviewer	
Quality Control FSM	

Revisions

No.	Date	Description
A	01.06.15	IFR
B	19.06.15	IFC
C	18.12.15	Building Permit App (AMS07/8)
D	11.03.16	DRB01/2/3 - IFR
E	24.03.16	DRB01/2/3 - IFC
F	13.05.16	Building Permit App (AMS07/8)

Registration

D+P RECEIVED FOR LOCAL CODE COMPLIANCE
DGM/R/SvB HAVE REVIEWED FOR FIRE

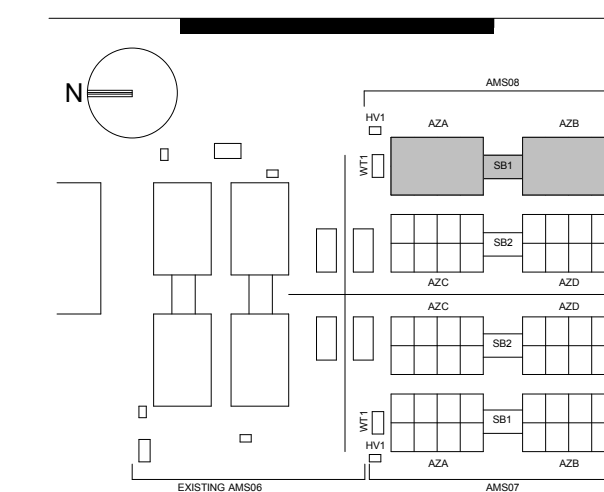


Barcode

Sheet Title/Number

ENLARGED
ELEVATIONS WEST AZ

A-H-03

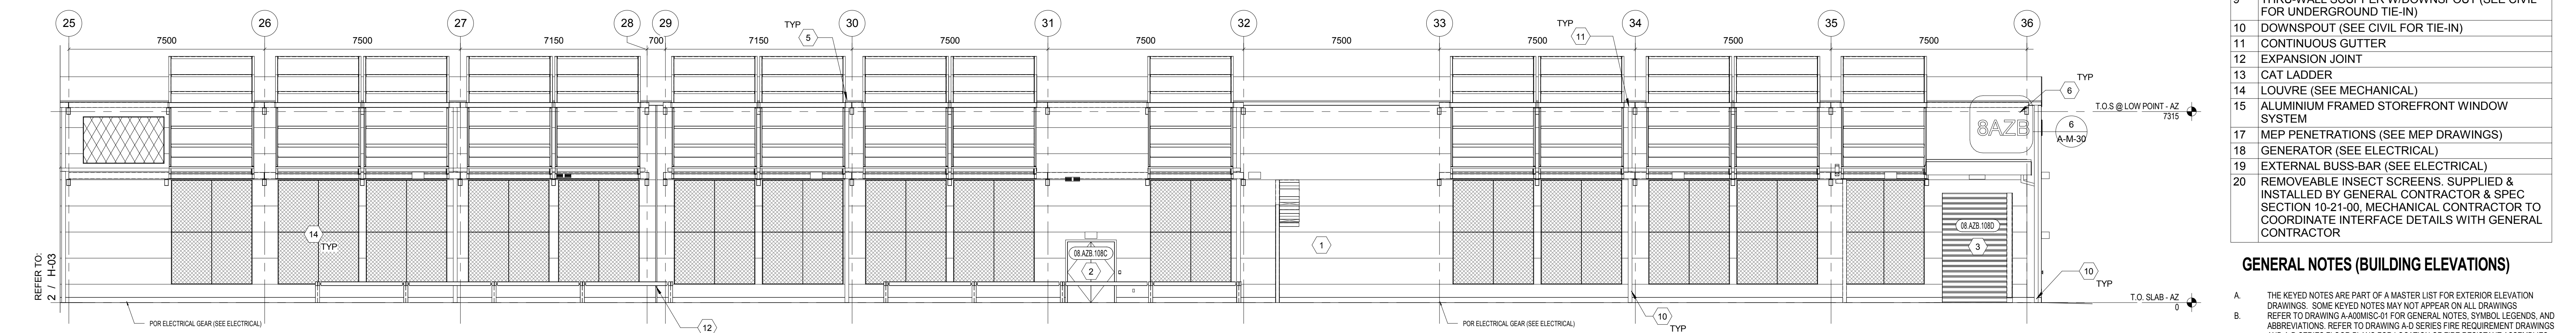

AZ WEST ELEVATION - AZB

SCALE: 1:100

•

KEYED NOTES - OVERALL ELEVATIONS AZ

- | | |
|----|--|
| 1 | INSULATED METAL PANEL - RAL: 7012 SLATE GREY PANELS & 150/50 20 JADE PANELS |
| 2 | SCHEDULED DOOR (SEE DOOR SCHEDULE) |
| 3 | OVERHEAD COILING DOOR (SEE DOOR SCHEDULE) |
| 4 | DUCTWORK (SEE MECHANICAL) |
| 5 | MEMBRANE ROOF |
| 6 | BUILDING IDENTIFICATION SIGNAGE; SEE SIGNAGE PLANS - RAL: 7035 LIGHT GREY LETTERING |
| 7 | TRASH COMPACTOR DOOR |
| 8 | CANOPY |
| 9 | THRU-WALL SCUPPER W/DOWNSPOUT (SEE CIVIL FOR UNDERGROUND TIE-IN) |
| 10 | DOWNSPOUT (SEE CIVIL FOR TIE-IN) |
| 11 | CONTINUOUS GUTTER |
| 12 | EXPANSION JOINT |
| 13 | CAT LADDER |
| 14 | LOUVRE (SEE MECHANICAL) |
| 15 | ALUMINUM FRAMED STOREFRONT WINDOW SYSTEM |
| 16 | MEP PENETRATIONS (SEE MEP DRAWINGS) |
| 17 | GENERATOR (SEE ELECTRICAL) |
| 18 | EXTERNAL BUSS-BAR (SEE ELECTRICAL) |
| 19 | REMOVE/ABSE INSECT SCREENS, SUPPLIED & INSTALLED BY GENERAL CONTRACTOR & SPEC SECTION 10-21-00, MECHANICAL CONTRACTOR TO PROVIDE INTERFACE DETAILS WITH GENERAL CONTRACTOR |

GENERAL NOTES (BUILDING ELEVATIONS)

- A. THE KEYED NOTES ARE PART OF A MASTER LIST FOR EXTERIOR ELEVATION DRAWINGS. SOME KEYED NOTES MAY NOT APPEAR ON ALL DRAWINGS.
- B. REFER TO DRAWING A-400M01-01 FOR GENERAL NOTES, SYMBOL LEGENDS, AND ABBREVIATIONS. REFER TO DRAWING A-40 SERIES FIRE REQUIREMENT DRAWINGS AND A-40 SERIES FLOOR PLANS FOR LOCATION OF FIRE RESISTANT ASSEMBLIES.
- C. REFER TO THE FINISH LEGEND & EXTERIOR FINISH DIAGRAM FOR ADDITIONAL MATERIALS AND COLOR INFORMATION.
- D. GENERATORS AND OTHER EQUIPMENT SHOWN IN THE FOREGROUND OF THE BUILDING ELEVATIONS ARE NOT SHOWN FOR CLARITY IN THE ENLARGED ELEVATIONS.
- E. REFER TO DETAILS IN THE AK ALL PIPES DRAWINGS FOR CONDUIT / PIPE WALL PENETRATION DETAILS. NOT ALL PIPE PENETRATIONS ARE SHOWN ON THE ELEVATIONS. REFER TO ELECTRICAL, MECHANICAL, PLUMBING, AND TELECOM DRAWINGS FOR ADDITIONAL INFORMATION.

Algemene opmerkingen (aanzichten)


A. De genummerde opmerkingen maken deel uit van de algemene lijst voor aanzichtingen. Sommige genummerde opmerkingen kunnen niet op alle tekeningen voorkomen

B. Raadpleeg tekening A-DOMSIC-001 voor algemene opmerkingen, symbool legendre en afkortingen. Raadpleeg tekening A-D serie brandstenen en A-D serie plattegronden voor de positie van brandwonder constructies.

C. Raadpleeg de afwerkingsstaat en de afwerkingsstaat voor het exterieur voor aanvullende informatie voor materiaal en kleur.

D. Generatoren en andere apparatuur die aangegeven wordt op de voorgrond van de gebouwaanzichtingen worden aangegeven ter verduidelijking


E. Raadpleeg tekening details voor tekening voor leiding en busdoosvoeren in muren. Niet alle busdoosvoeren worden aangegeven op de aanzichttekening. Raadpleeg de installatieteekeningen voor aanvullende informatie.

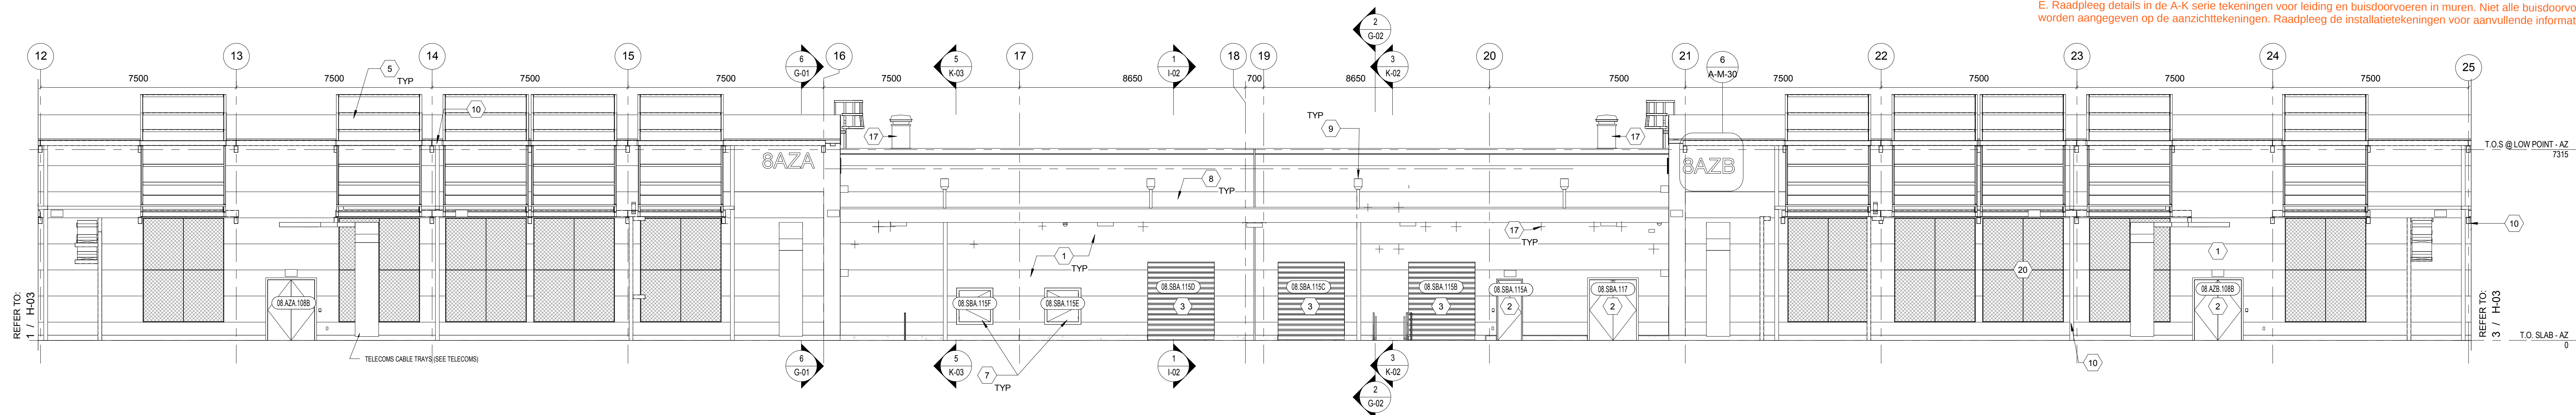

AZ WEST ELEVATION - SBA

SCALE: 1:100

•

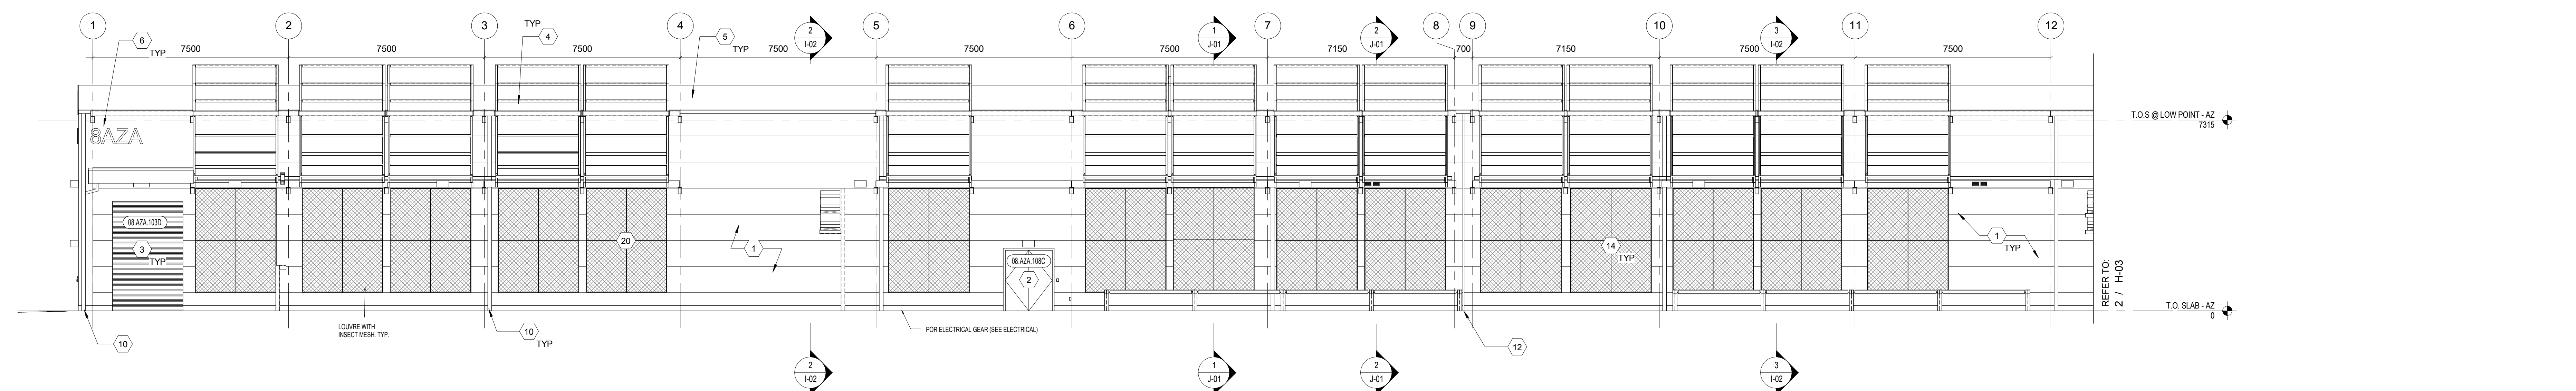

AZ WEST ELEVATION - AZA

SCALE: 1:100

ALL VERTICAL DIMENSIONS ARE RELATIVE TO ASSOCIATED BUILDING SLAB LEVEL.

MICROSOFT CONFIDENTIAL

4-03