


3F

2F

1F

GF

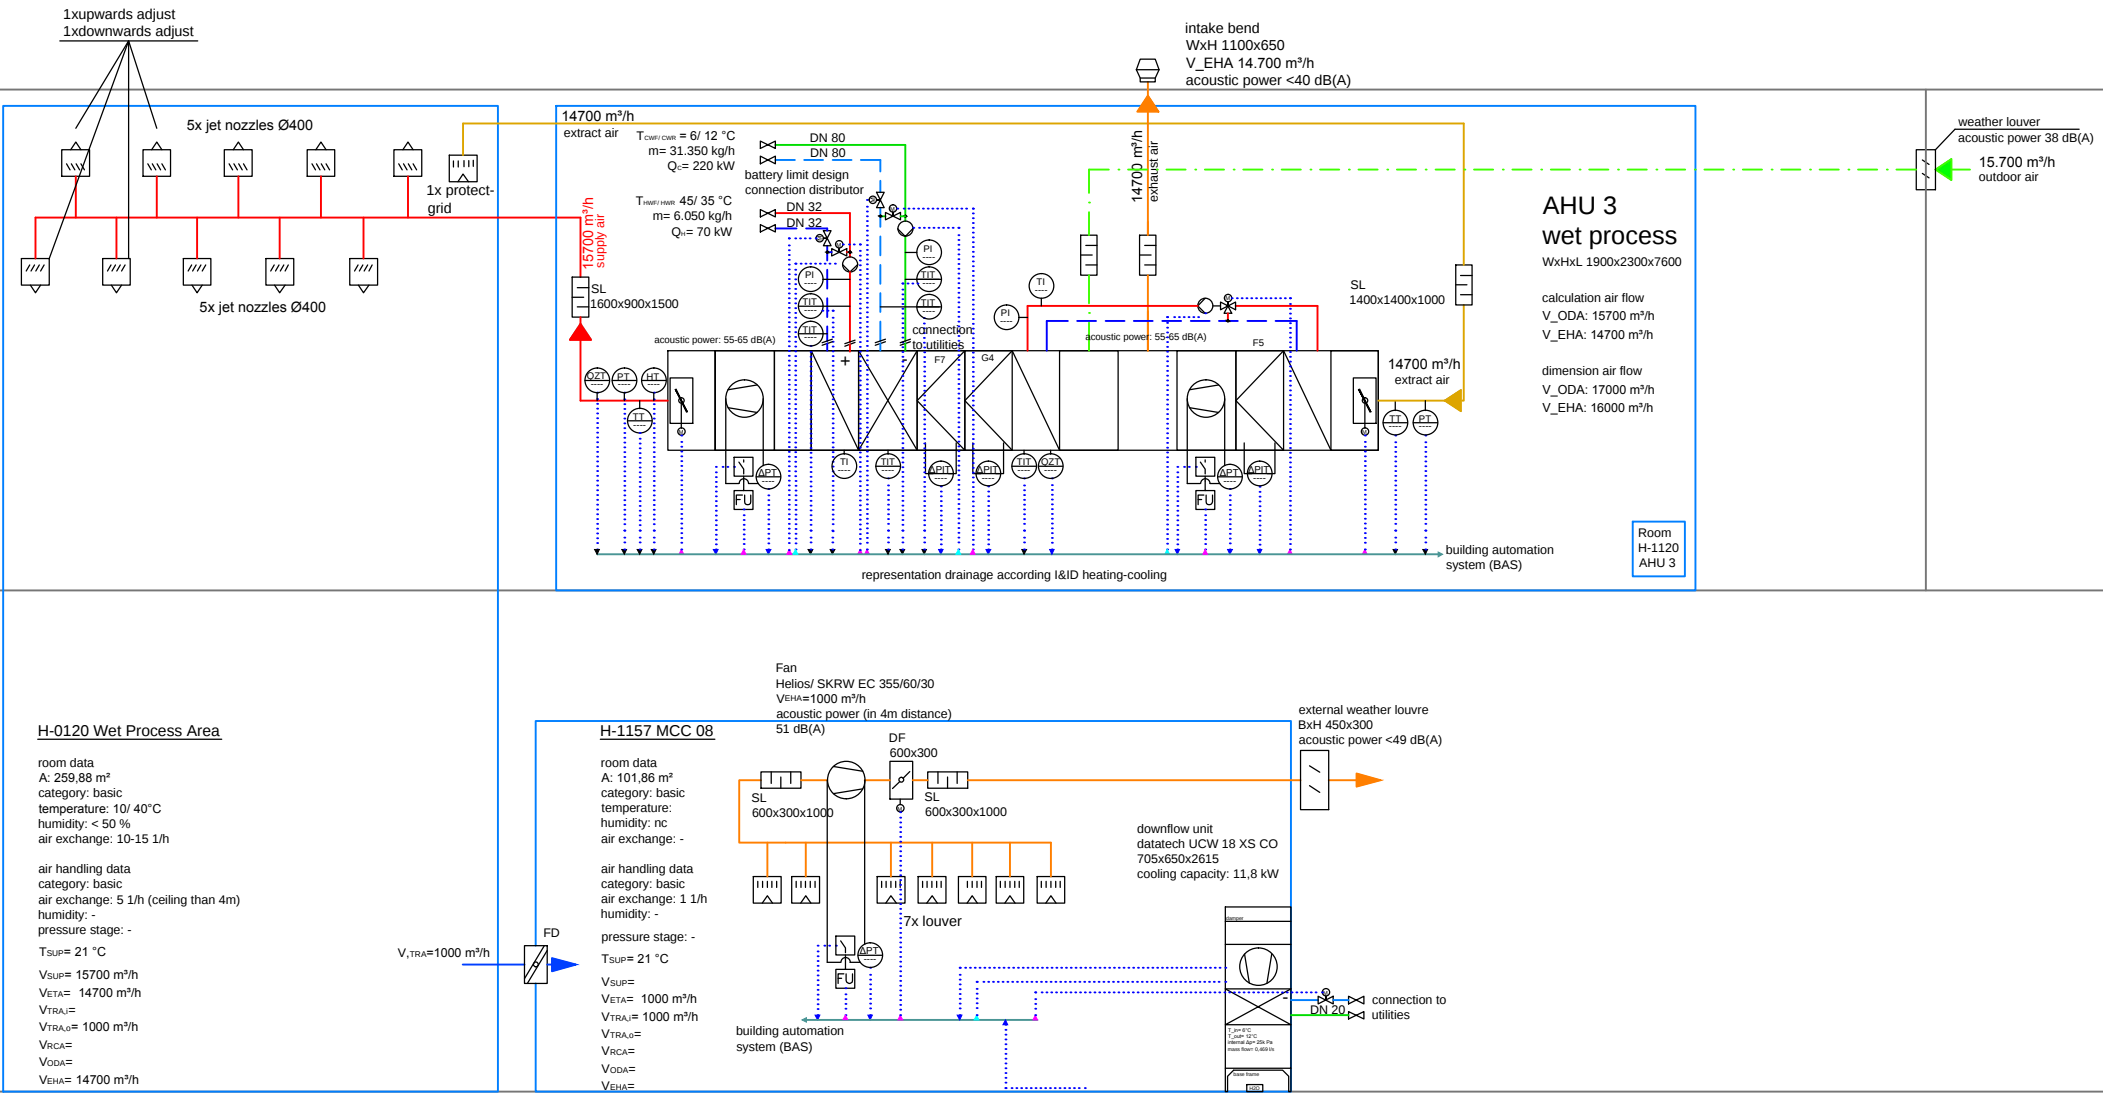

description:

 
- chilled water forward flow
- chilled water return
- heating forward flow
- heating return
- building automation system (BAS)
- outdoor air
- exhaust air
- extract air
- supply air
- transferred air

- extract air outlet
- supply air outlet
- tube outlet
- mousehole
- louver
- fire damper (FD)
- constant volume flow regulator (CFR)
- fan
- droplet separator
- variable volume flow regulator (VFR)
- damper flap (DF)
- filter
- silencer (SL)
- pre-heater (PH)
- external louver
- shut-off-valve
- balancing valve
- pump
- check valve (CV)
- deflector hood
- motor actuator
- three-way-valve
- instrument connected to BAS with a local indication
- instrument connected to BAS without a local indication
- instrument with local indication
- pressure
- humidity
- differential pressure
- frost protection
- smoke
- leakage monitoring
- analog input
- analog output
- digital input
- digital output

number contained in plan:

- plan P&ID's AHU5/ AHU8
- plan P&ID's AHU5/ AHU8
- plan P&ID's AHU5/ AHU8
- plan P&ID's AHU5/ AHU8
- plan P&ID's AHU5/ AHU6
- plan P&ID's AHU1+2/ CIP

-	-	-	---
-	-	-	---
B	10.08.2015	adaptation symbolism according nestlé standard	SHe
A	12.07.2015	adaption labeling	SHe
index	date	changed	drawn by

cad design: \CAD\							
this plan replaced plan number: -							
builder: Detailed Engineering Design Freeze for preparation of technical specifications for tendering approved by discipline responsible Date Roel Engelen Jens Hohenacker				engineering consultant:  liebert INGENIEURBÜRO FÜR VERSORGUNGSTECHNIK Hohenstraße 17 Tel. +49 (0)771/1589790 e-Mail: info@liebert-ing.de 78183 Hüfingen Fax +49 (0)771/15897933 Homepage: http://www.liebert-ing.de			
this plan is the exclusive property of IB-Liebert and shall not be disclosed or reproduced without its written authorization							
project status: detail-design				reference hight: -			
project: Nestlé Netherlands 				title: P&ID's AHU 3 schematic detail-design			
agent: ---		drawn by: ---		date: 13.07.2015		scale: 1 : paper-size: A2	
plannumber: 753 1779 --- 05C 0202 -B --							
project	building number	section	plan type	plan number	index	grid square	