



10040
70
5010
1150
1630
220
1700
260

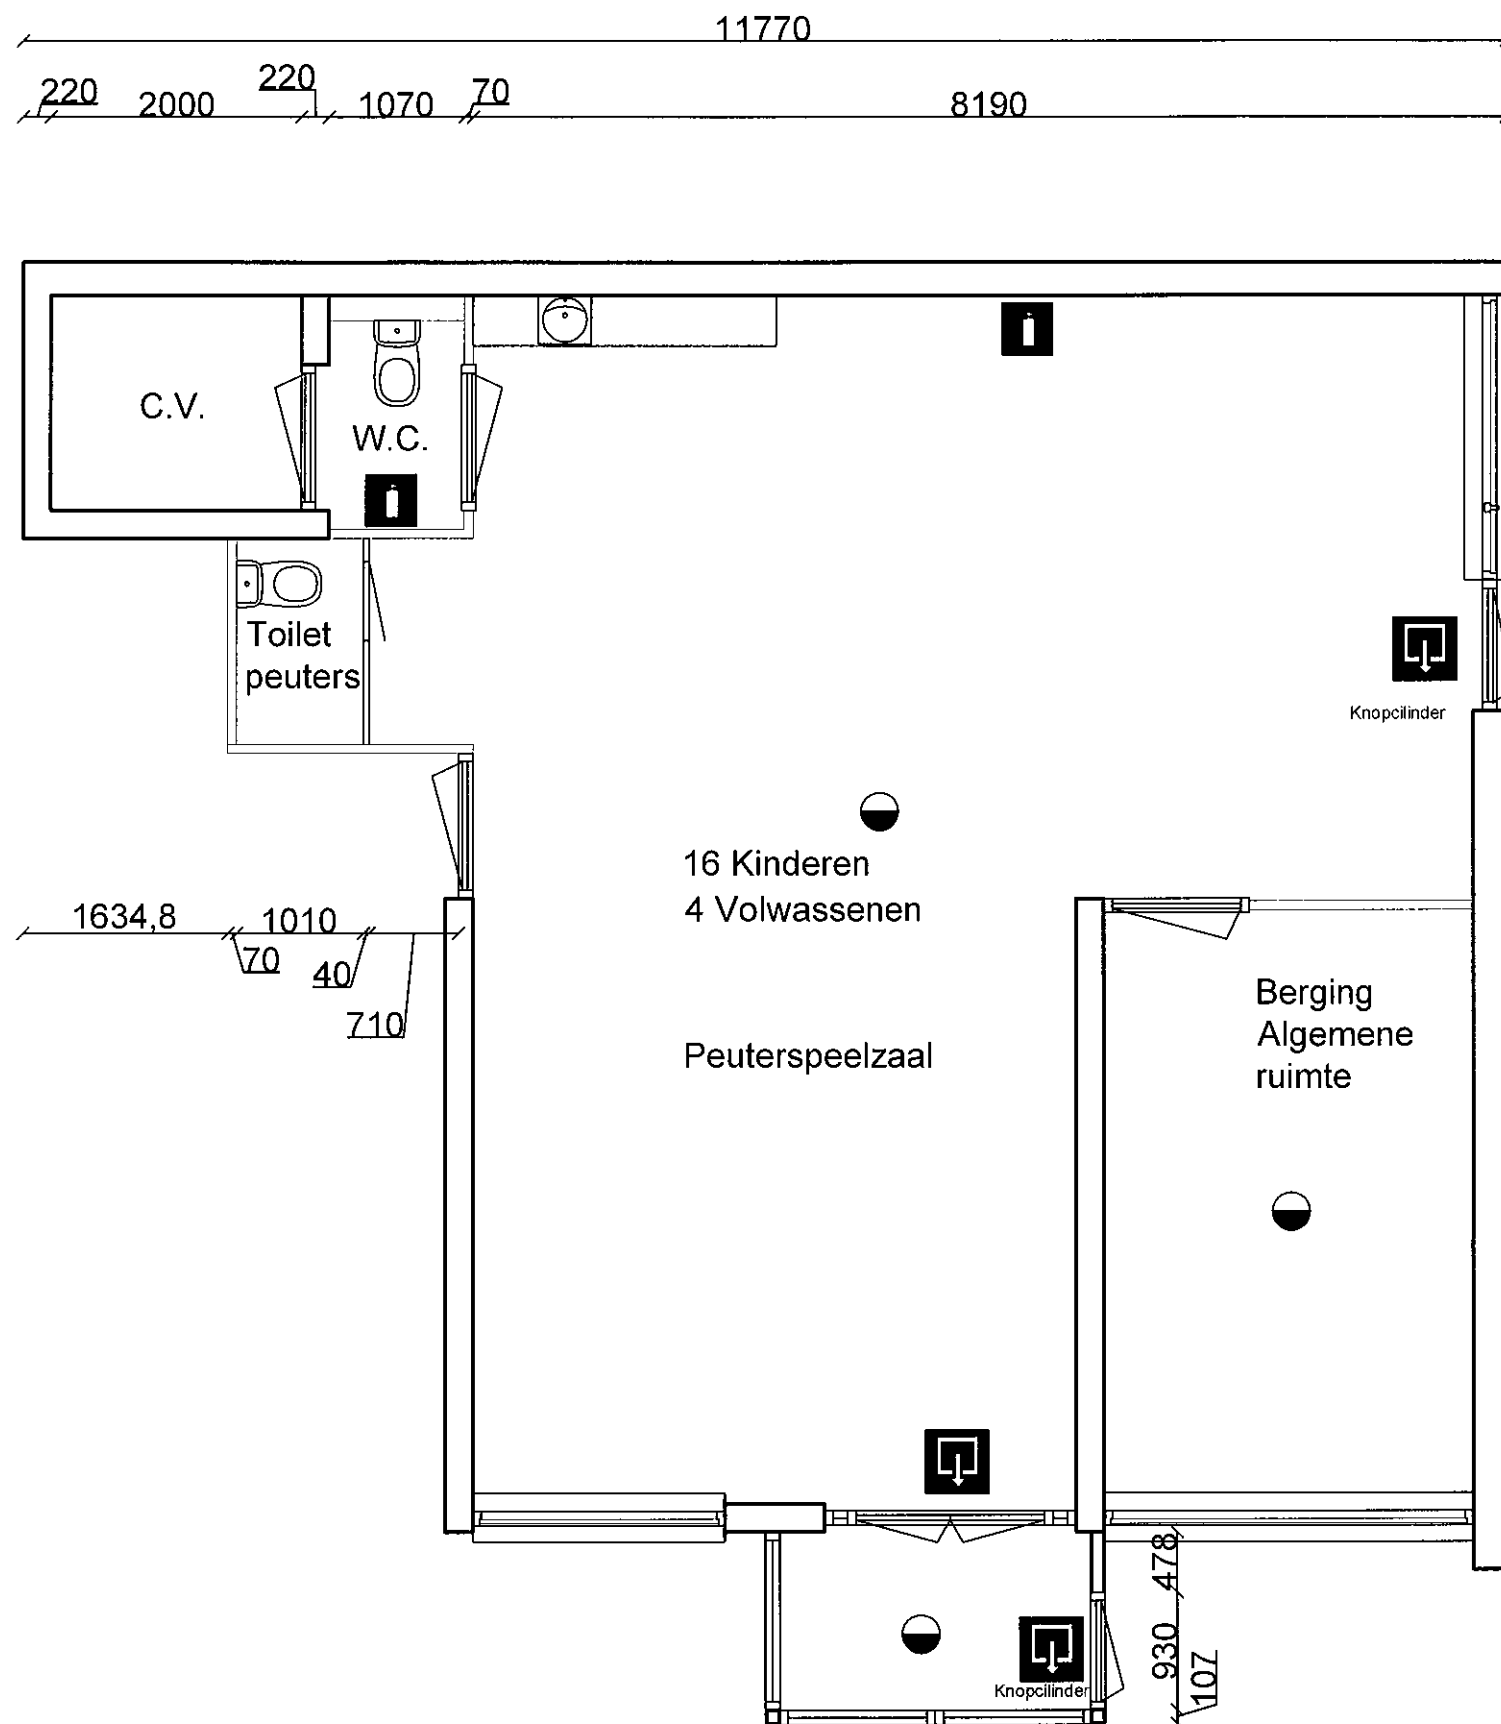

260
2256
1034
1502
70
4754
114
350
10340

220 2000 315 108 2477 100 2930 260

-  brandblusser
6 liter schuim
-  rookmelder
220 volt
-  nooduitgang

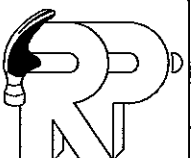	project - SKL, 3 Turven S.van Drielstraat 6	
	Tekening - Plattegrond- Brandveiligheid	
	Datum -	1-18-06-19 2-// 3-// 4-//
	getekend - YB	
Schaal - 1:60		
Maateenheid - mm	Blad - A3	
René Pieterse B.V. TIMMER- EN AANNEMINGSBEDRIJF www.pietersebv.nl		